



REVISIONS:


No.	Description	Date
1	ADDENDUM NO. 3	08/31/16

PROJECT: 7201-147780
DATE: DECEMBER 12, 2016
DRAWN BY: KAFFM/MPS
CHECKED BY: MAC

**ELECTRICAL
SITE PLAN**

E-011R

1 ELECTRICAL SITE PLAN
SCALE: 1" = 40'-0"

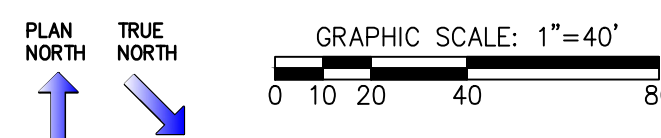

KEYED NOTES:

- 1 COMMUNICATIONS SERVICE CONDUITS. TERMINATION POINT INSIDE BUILDING SHALL BE HIGHER THAN THE HANDHOLE ENTRY POINT.
- 2 (2) 4"C & (2) 2"C SPARES FOR FUTURE. INDICATE LOCATION ON AS/BUILT DRAWINGS. TERMINATE AT 36"x36" QUAZITE HANDHOLE.
- 3 (2) 2"C SPARE FOR FUTURE. INDICATE LOCATION ON AS/BUILT DRAWINGS. TERMINATE AT 24"x24" QUAZITE HANDHOLE.
- 4 THE CONTRACTOR'S SCOPE INCLUDES INSTALLATION OF CONDUITS ONLY FOR JONES-ONSLow USE ONLY. CONDUCTORS, BASES, POLES, AND FIXTURES WILL BE INSTALLED BY JONES-ONSLow.
- 5 CANOPY LIGHTS: ALTERNATE 13-A
- 6 CANOPY LIGHTS: ALTERNATE 13-B

