




S:\Projects 2021\22023 HVAC Replacements BHPHS-HPES-BES Drawings\Revit
M103\22046\22046-01 HVAC Replacement - Base Plan - R22.rvt

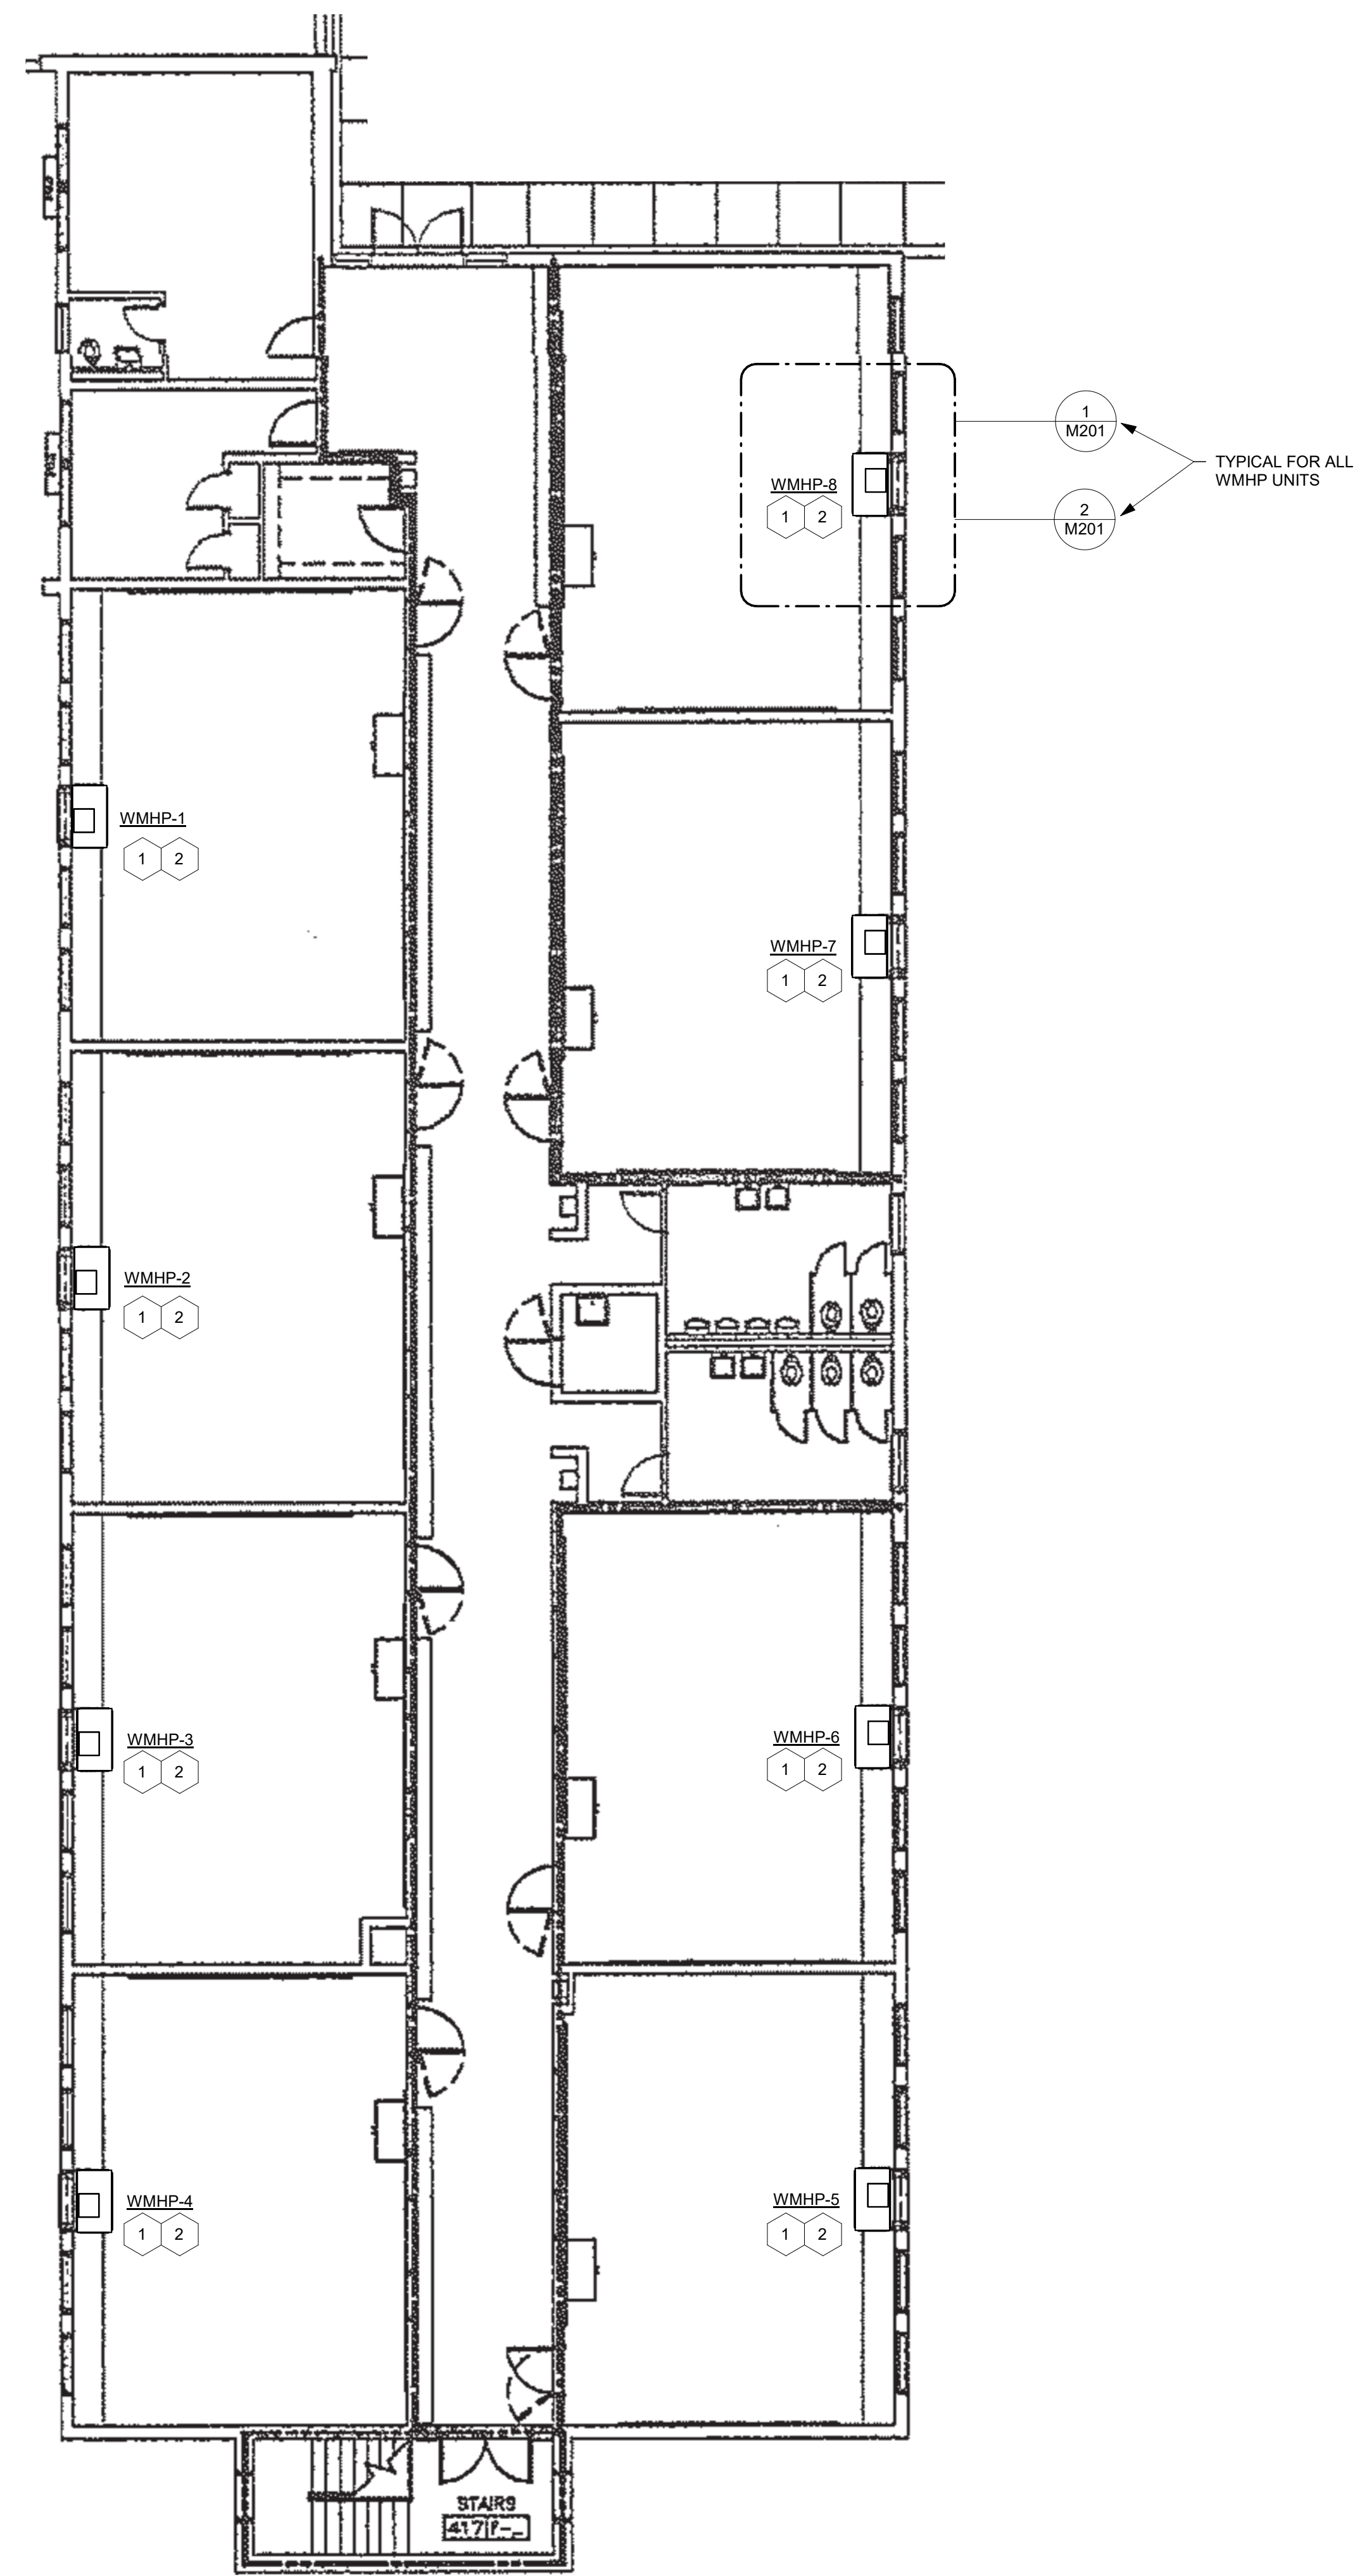


2 HVAC Plan - Area D Upper Level
1/8" = 1'-0"

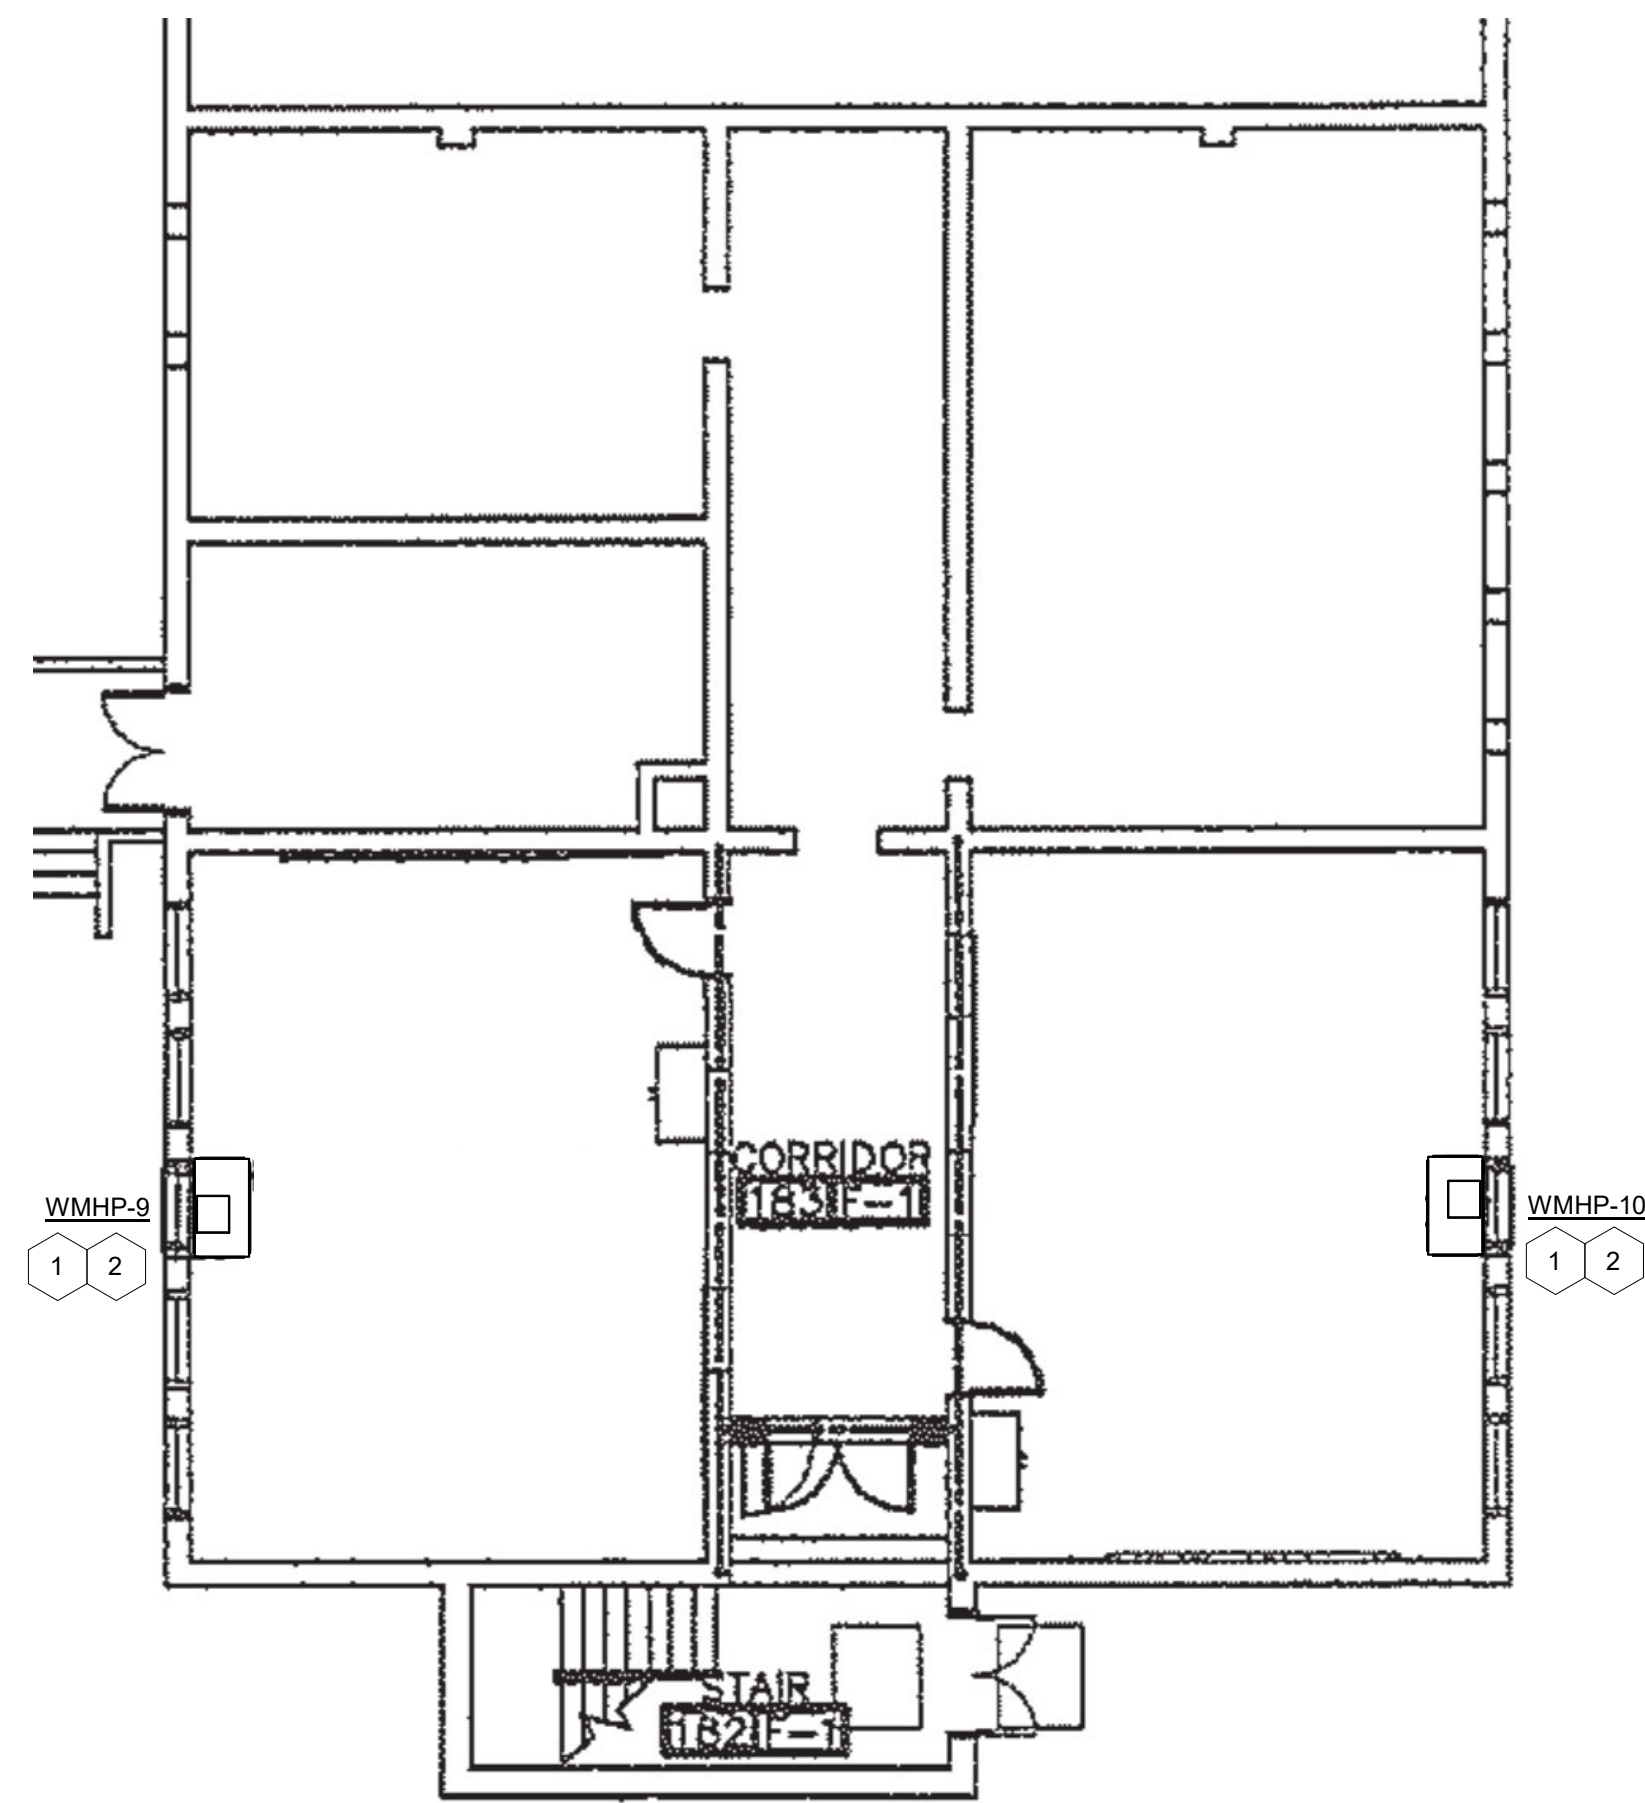

4 HVAC Plan - Area D Lower Level
1/8" = 1'-0"

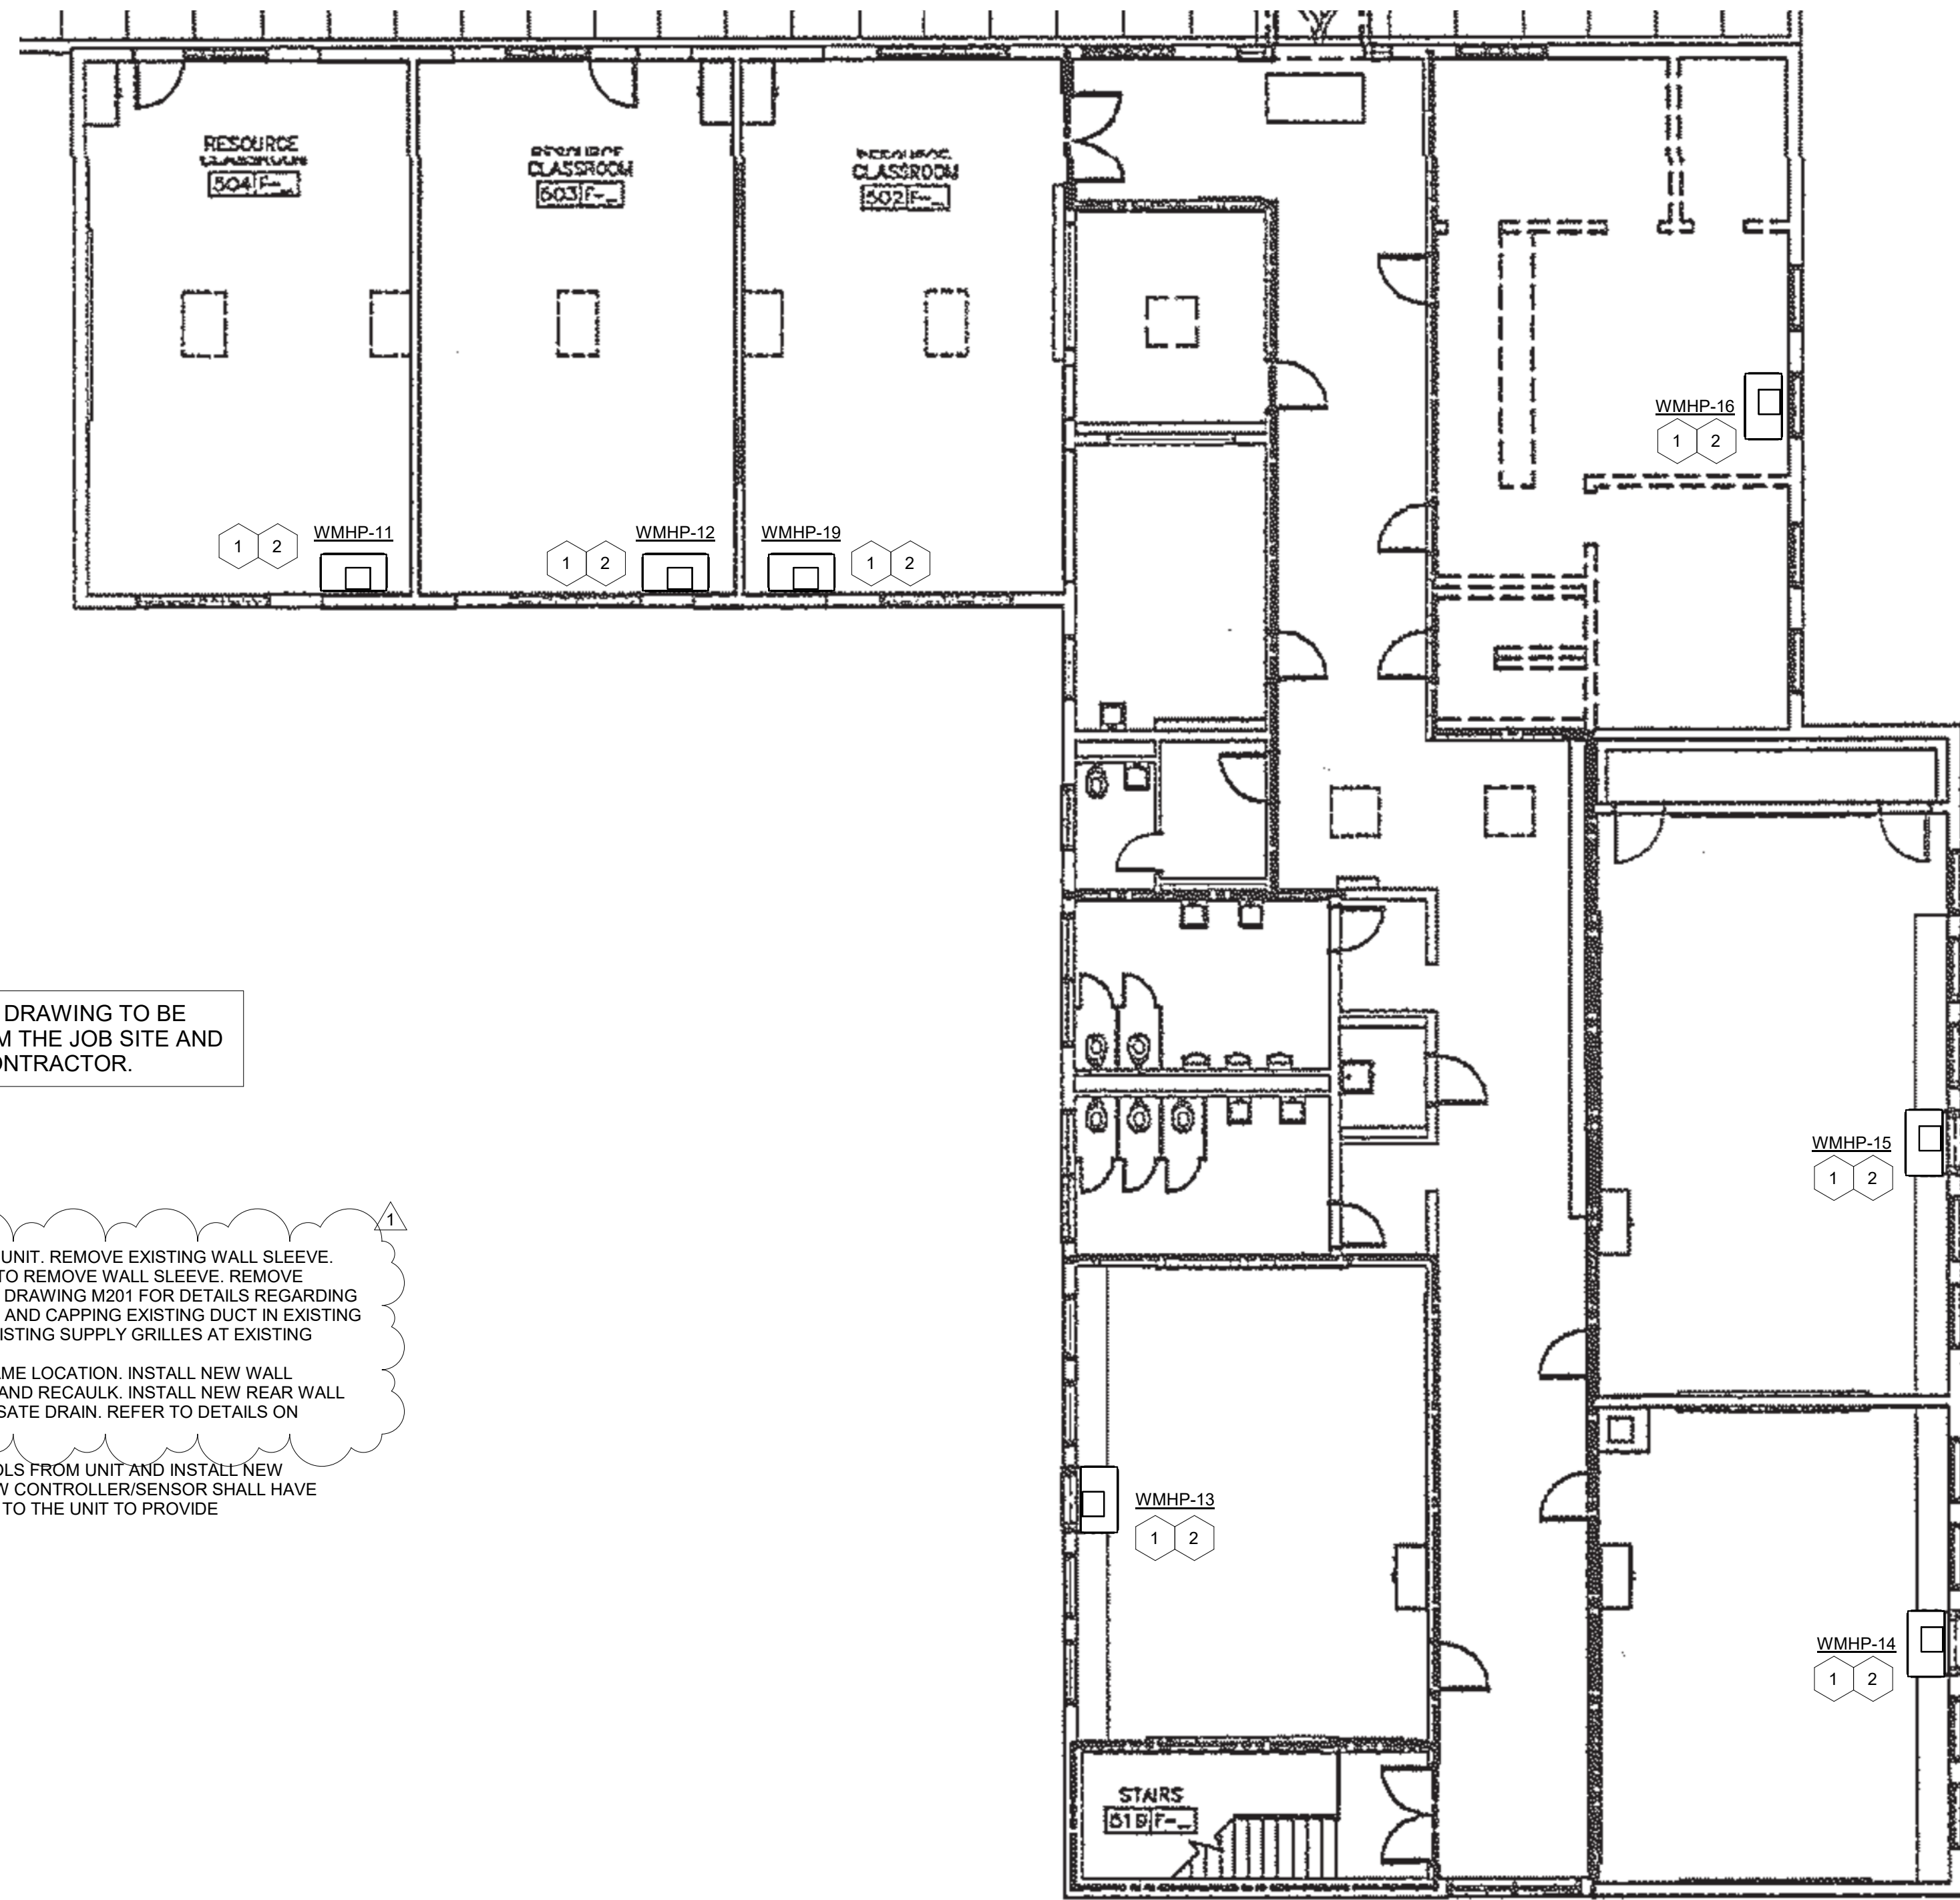

1 HVAC Plan - Area C Upper Level
1/8" = 1'-0"

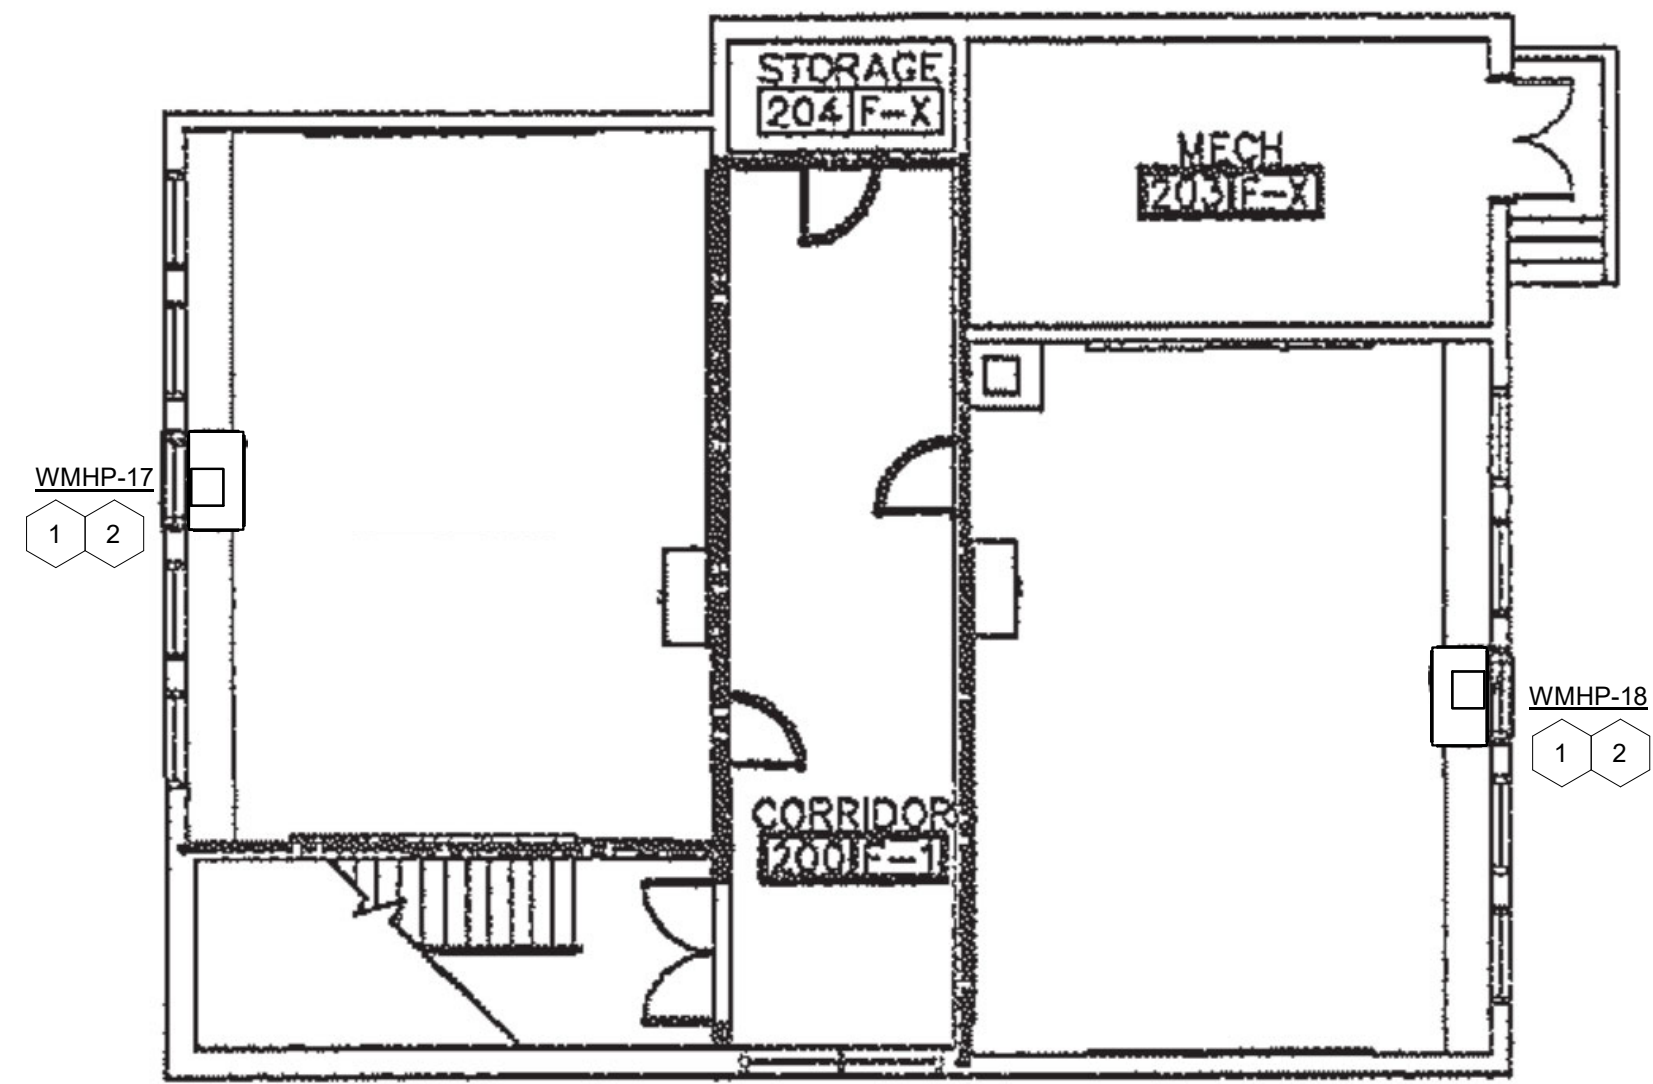

3 HVAC Plan - Area C Lower Level
1/8" = 1'-0"

ALL EQUIPMENT INDICATED ON THIS DRAWING TO BE REMOVED SHALL BE REMOVED FROM THE JOB SITE AND PROPERLY DISPOSED OF BY THE CONTRACTOR.

KEYED NOTES:


- 1 REMOVE EXISTING VERTICAL HEAT PUMP UNIT. REMOVE EXISTING WALL SLEEVE. REMOVE EXISTING PLENUM EXTENSION. REFER TO DRAWING M201 FOR DETAILS REGARDING REMOVING PORTION OF SOFFIT, CUTTING AND CAPPING EXISTING DUCT IN EXISTING SOFFIT, AND REMOVING AND CAPPING EXISTING SUPPLY GRILLES AT EXISTING SOFFIT. INSTALL NEW VERTICAL HEAT PUMP IN SAME LOCATION. INSTALL NEW WALL SLEEVE. REINSTALL LOUVER AS NEEDED AND RECAULK. INSTALL NEW REAR WALL SIDE TRIM PIECES. RECONNECT CONDENSATE DRAIN. REFER TO DETAILS ON DRAWING M201.
- 2 REMOVE EXISTING CONTROLLER/CONTROLS FROM UNIT AND INSTALL NEW CONTROLLER/SENSOR ON NEW UNIT. NEW CONTROLLER/SENSOR SHALL HAVE SPACE HUMIDITY SENSOR AND CONNECT TO THE UNIT TO PROVIDE DEHUMIDIFICATION CONTROL.

CRAIG GAULDEN DAVIS

● Architecture
Planning
Interiors
19 Washington Park
Greenville, SC 29601
Phone 864.242.0761
Fax 864.501.9945
Email cgd@gdarch.com

COPYRIGHT © 2022 CRAIG GAULDEN & DAVIS, INC.
ALL RIGHTS RESERVED

THIS COPYRIGHTED DOCUMENT AND ALL INFORMATION CONTAINED HEREIN IS AN INSTRUMENT OF SERVICE AND SHALL NOT BE REPRODUCED, ALTERED, OR REUSED IN PART OR IN WHOLE WITHOUT PRIOR WRITTEN PERMISSION FROM THE ARCHITECT. THIS DRAWING IS THE EXCLUSIVE PROPERTY OF THE ARCHITECT AND MUST BE RETURNED UPON REQUEST.

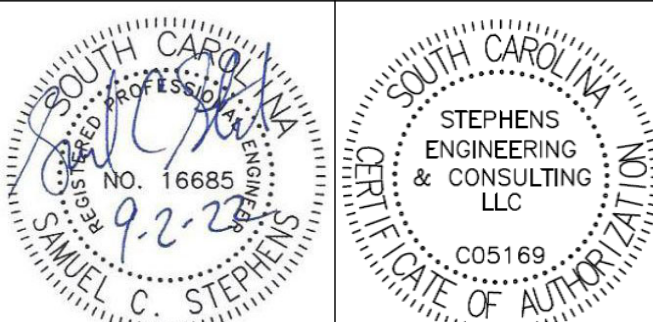

CONSULTANT

SE&C

HVAC • PLUMBING • FIRE PROTECTION
STEPHENS ENGINEERING & CONSULTING, LLC
130 HERITAGE LANE
EASLEY, SC 29642
(864) 414-1965

ANDERSON SCHOOL DISTRICT TWO

BELTON ELEMENTARY SCHOOL
HVAC REPLACEMENT

202 Watkins St., Belton, SC 29627

22046

DATE	MARK	DESCRIPTION
10/12/2023	1	Addendum #1

ISSUE: CONSTRUCTION DOCUMENTS
DATE: 09/02/22
PROJECT NO: 22046
DRAWN BY: SCS
CHECKED BY: SCS

HVAC PLANS
AREAS C & D

M103