


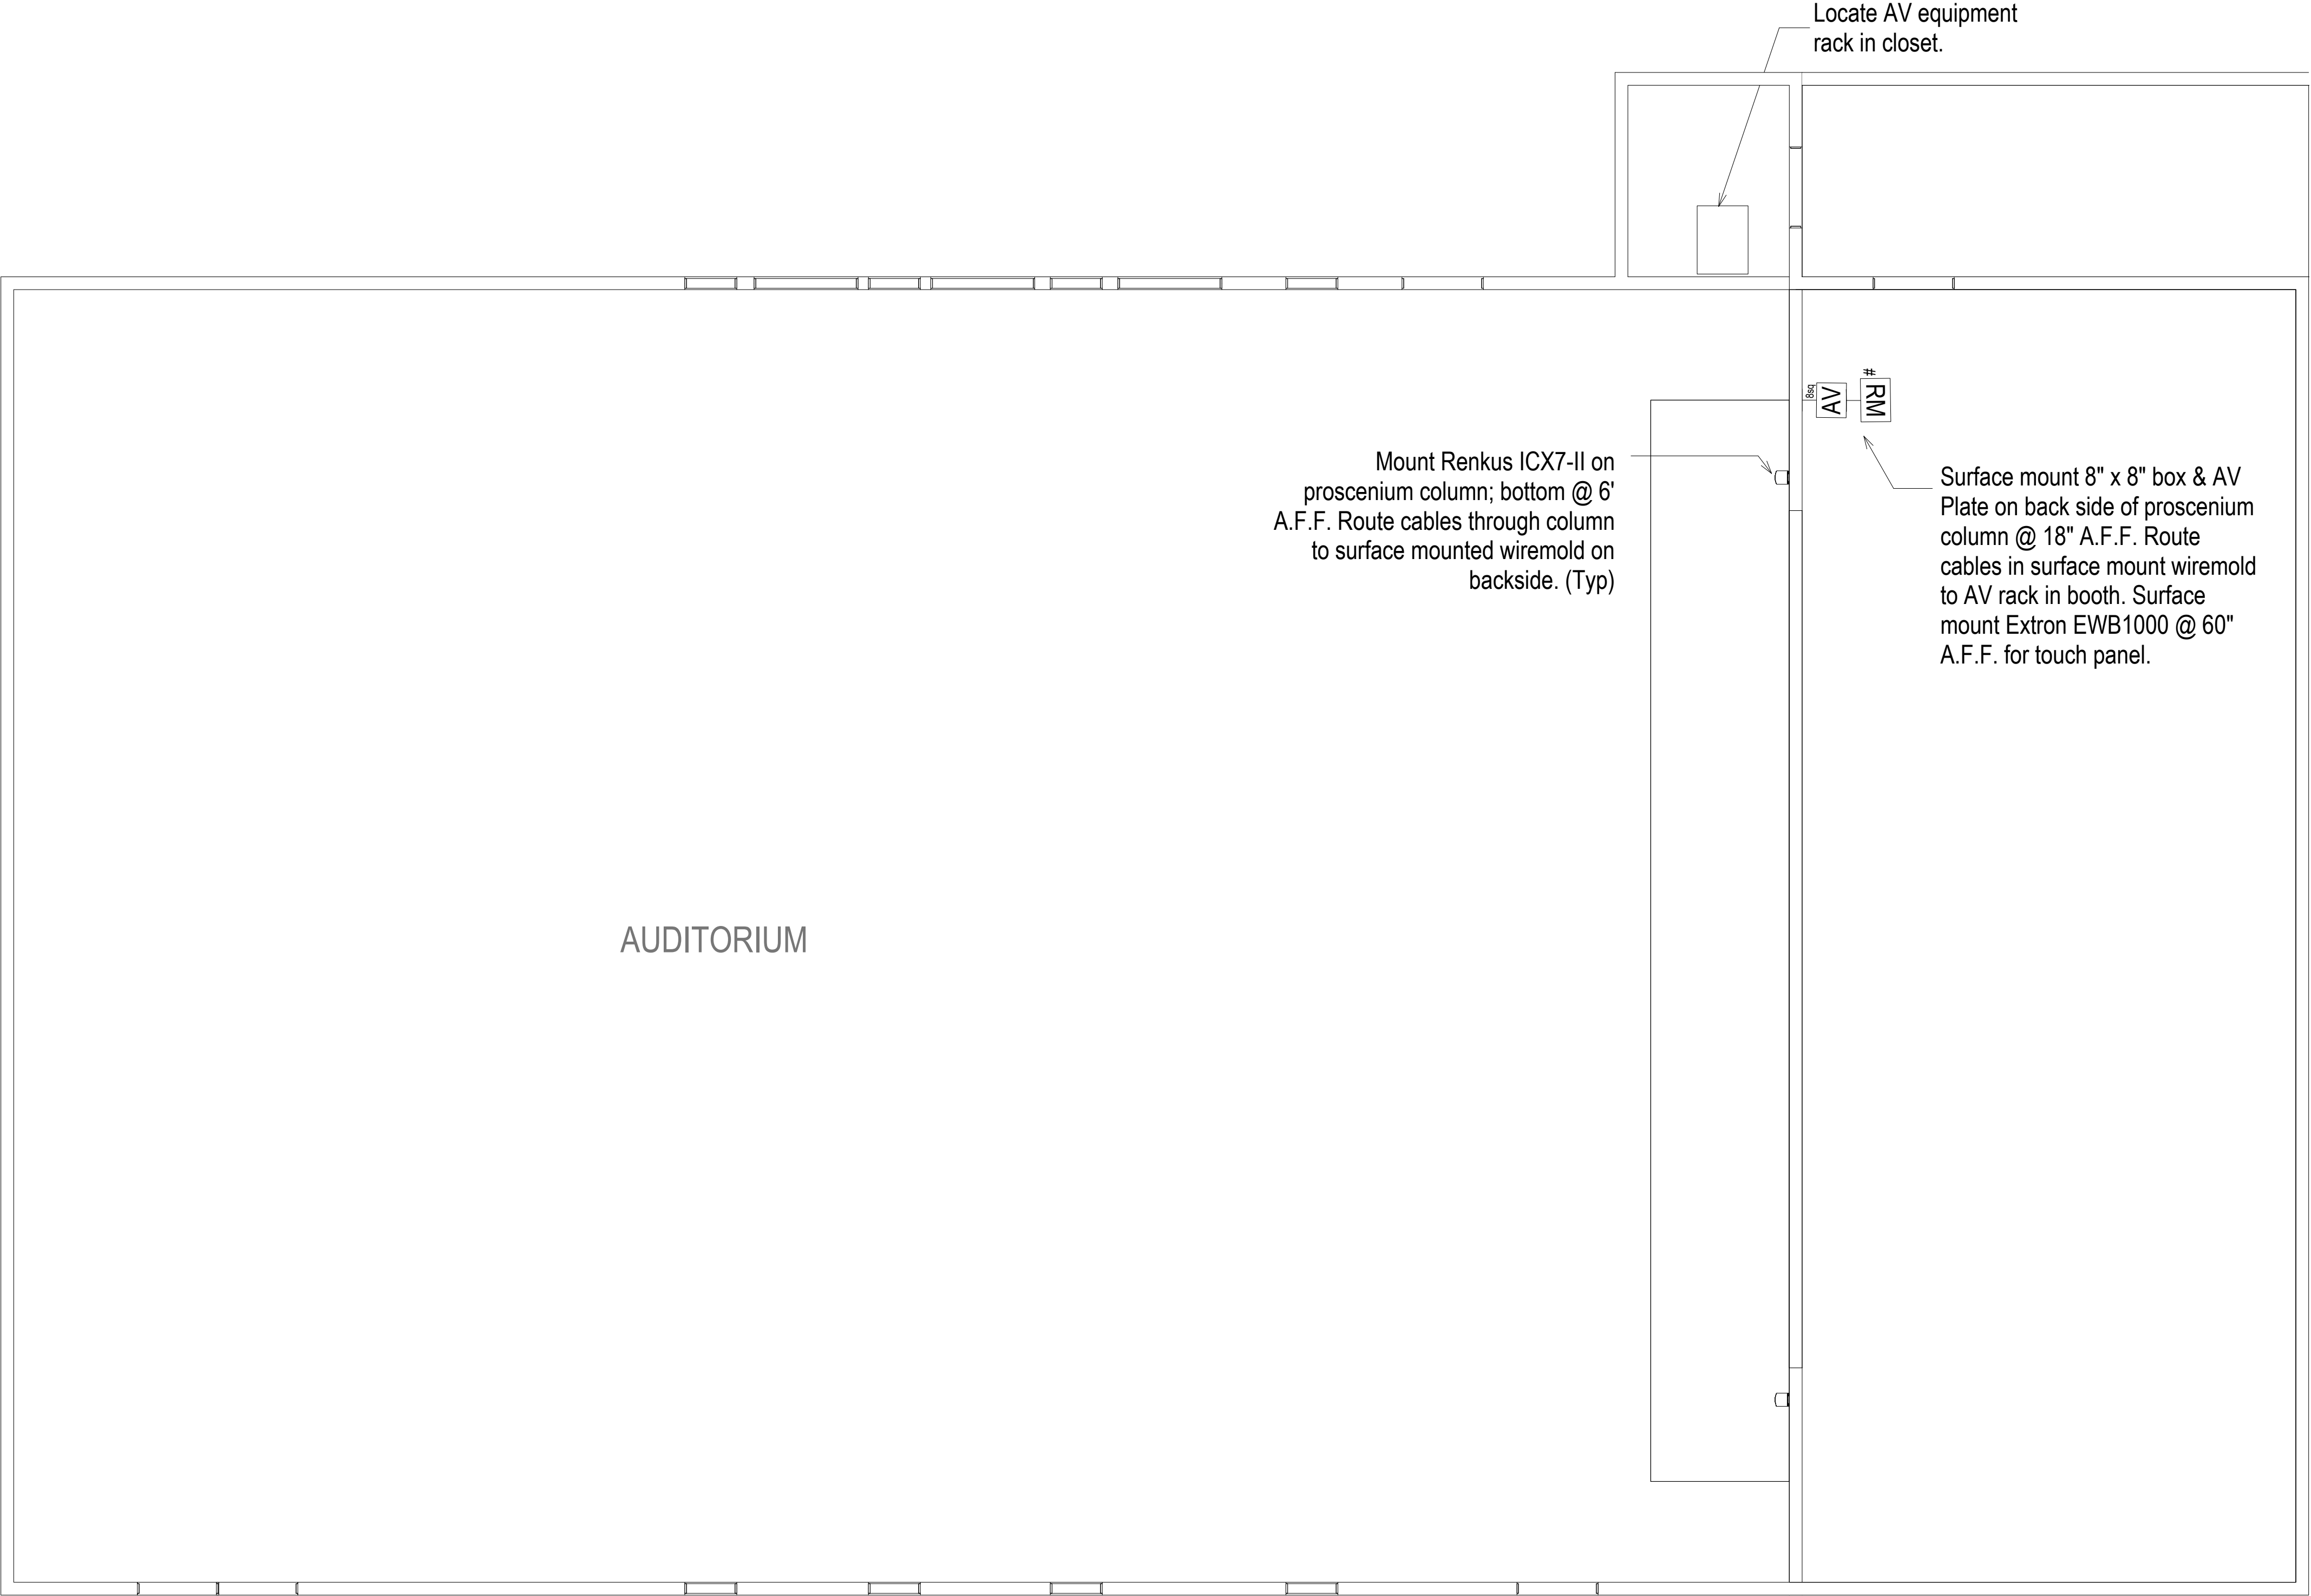

Locate AV equipment rack in closet.

Mount Renkus ICX7-II on proscenium column; bottom @ 6' A.F.F. Route cables through column to surface mounted wiremold on backside. (Typ)

Surface mount 8" x 8" box & AV Plate on back side of proscenium column @ 18" A.F.F. Route cables in surface mount wiremold to AV rack in booth. Surface mount Extron EWB1000 @ 60" A.F.F. for touch panel.

AUDITORIUM

1 AV Floor Plan
Scale: 1/4" = 1'-0"

Walthall & Associates

Consultants in Acoustics, Audio-Visual & Digital Technologies

2180 Coughlin Road
Pensacola, FL 32504
(850) 478-5002

Revisions:

Auditorium Audio-Visual System

Bulter Elementary School
6694 W County Highway 30A
Santa Rosa Beach, FL

AV 1st Floor Plan


Issue Date:
8/13/14
PRICING

Drawn by: CW


Checked by: CW

Project #


AV-1

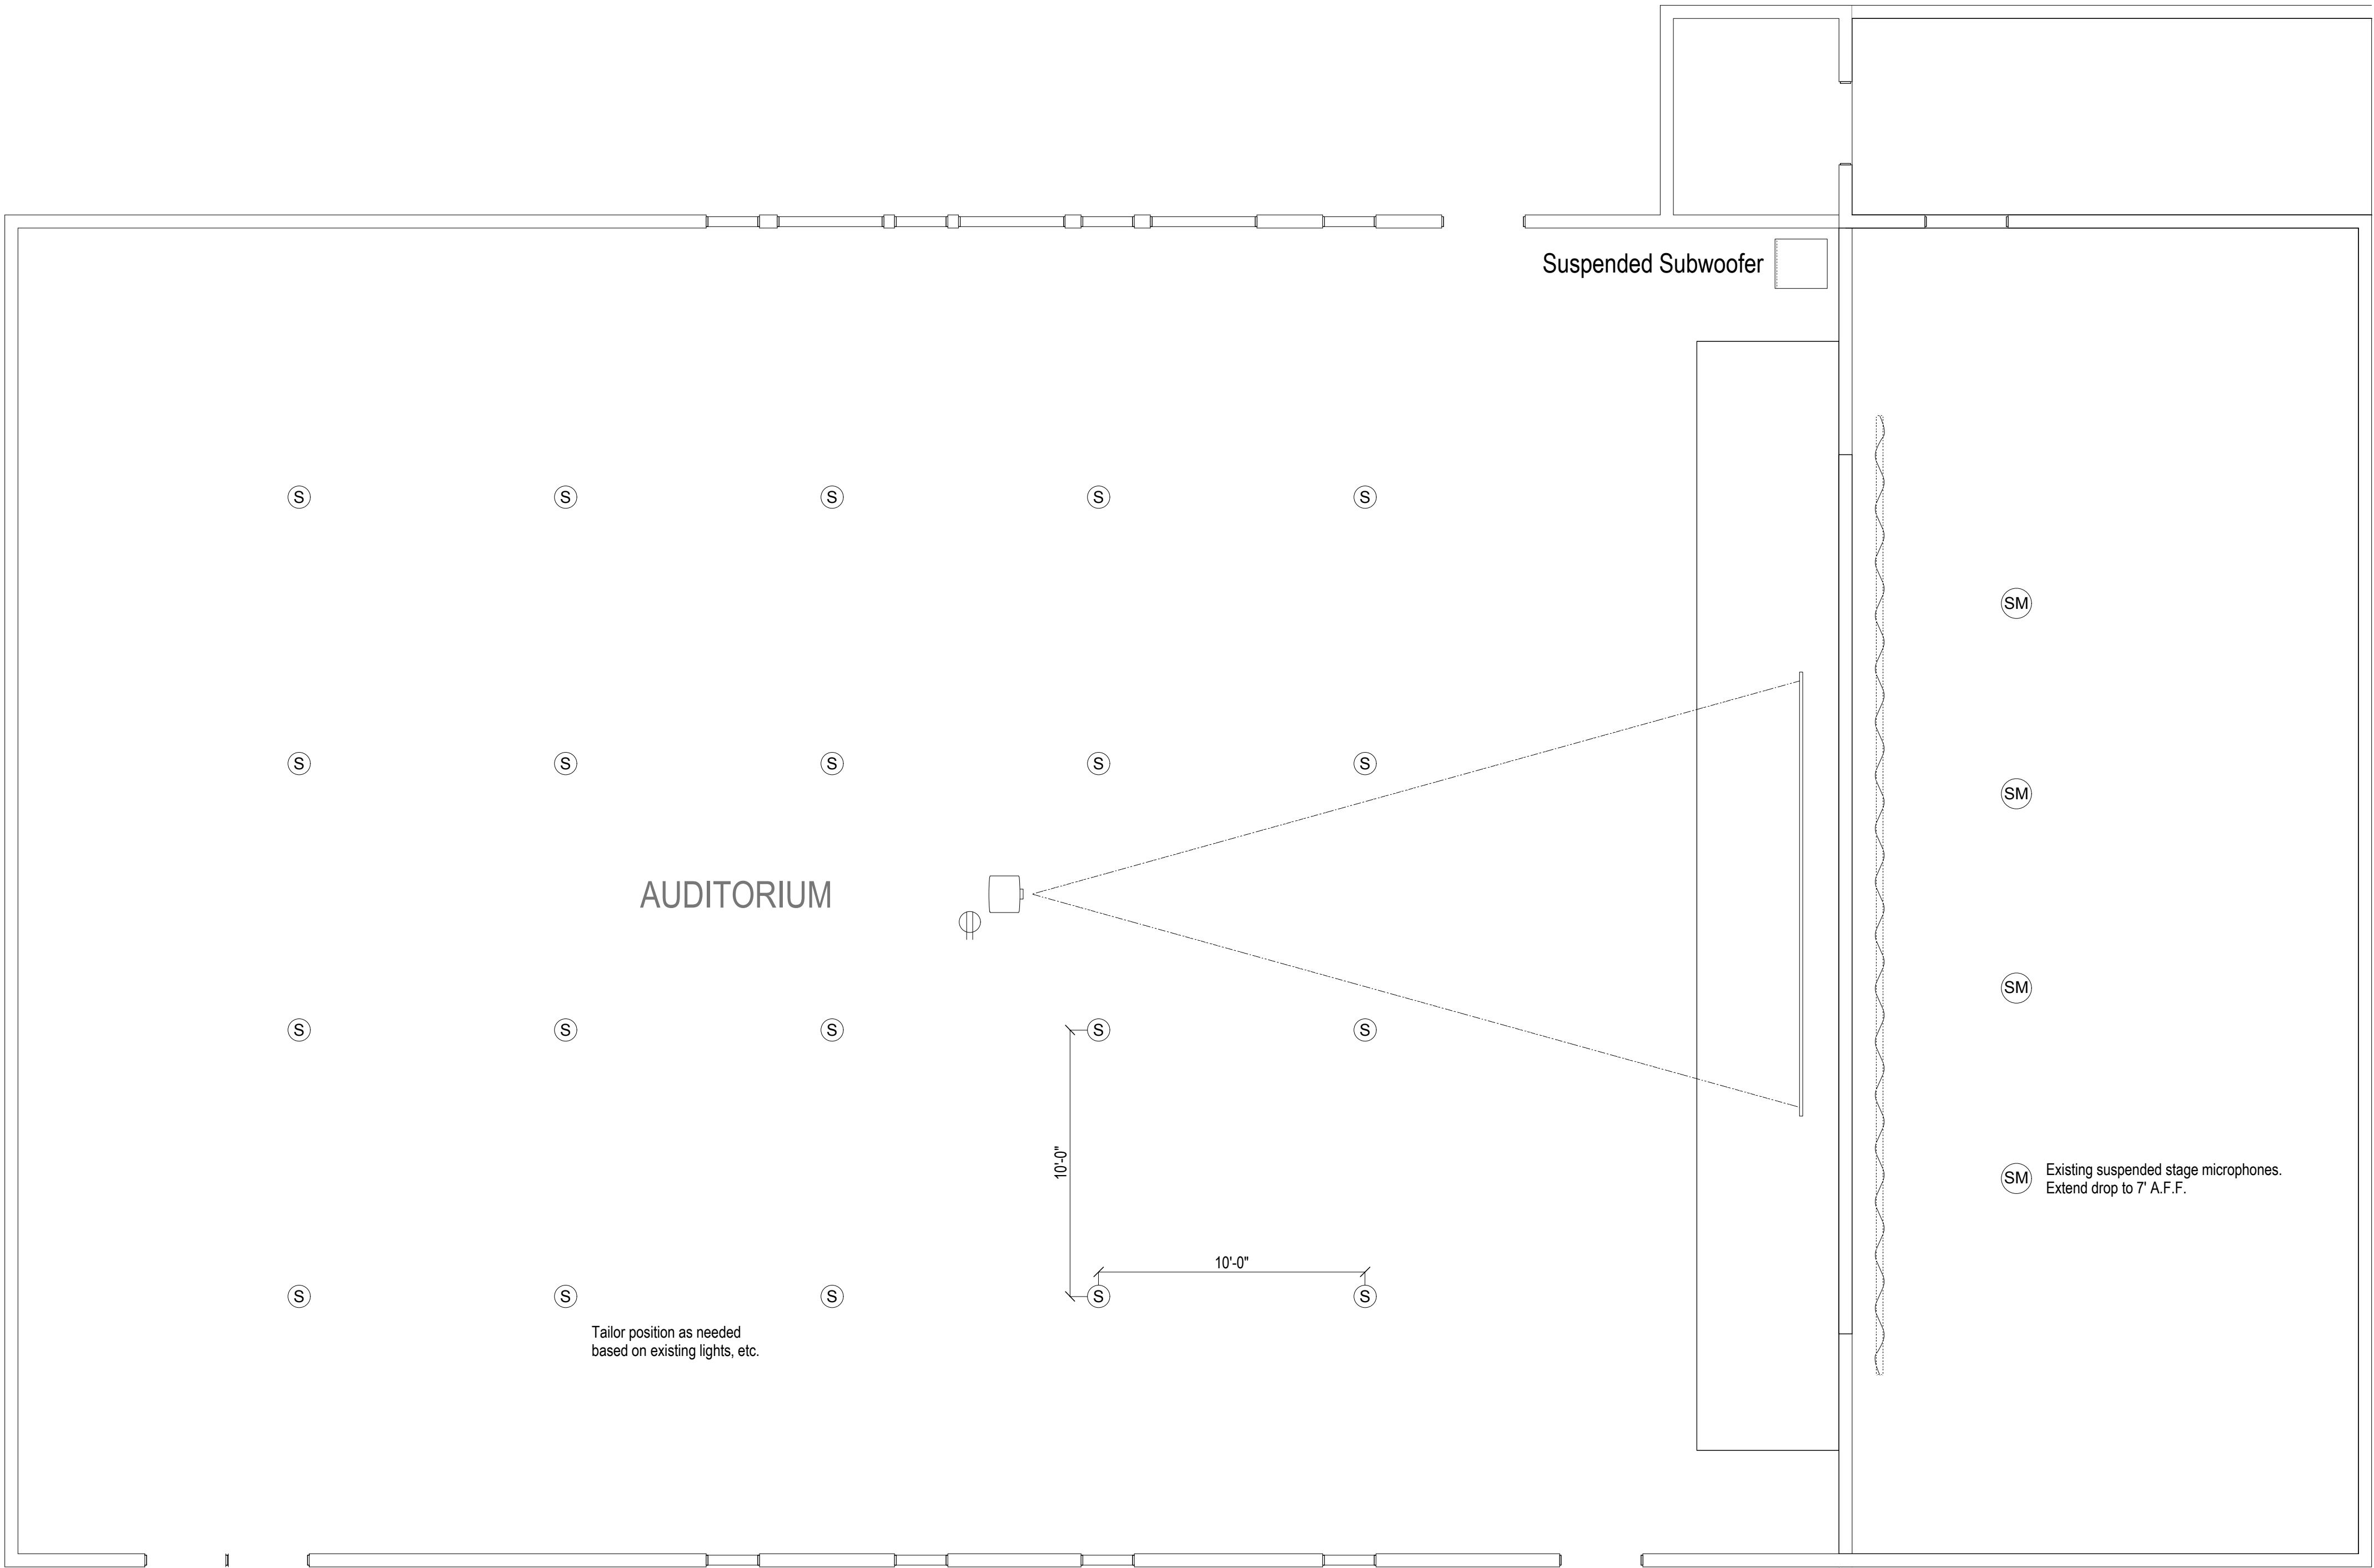


1 AV Reflected Ceiling Plan
Scale: 1/4" = 1'-0"

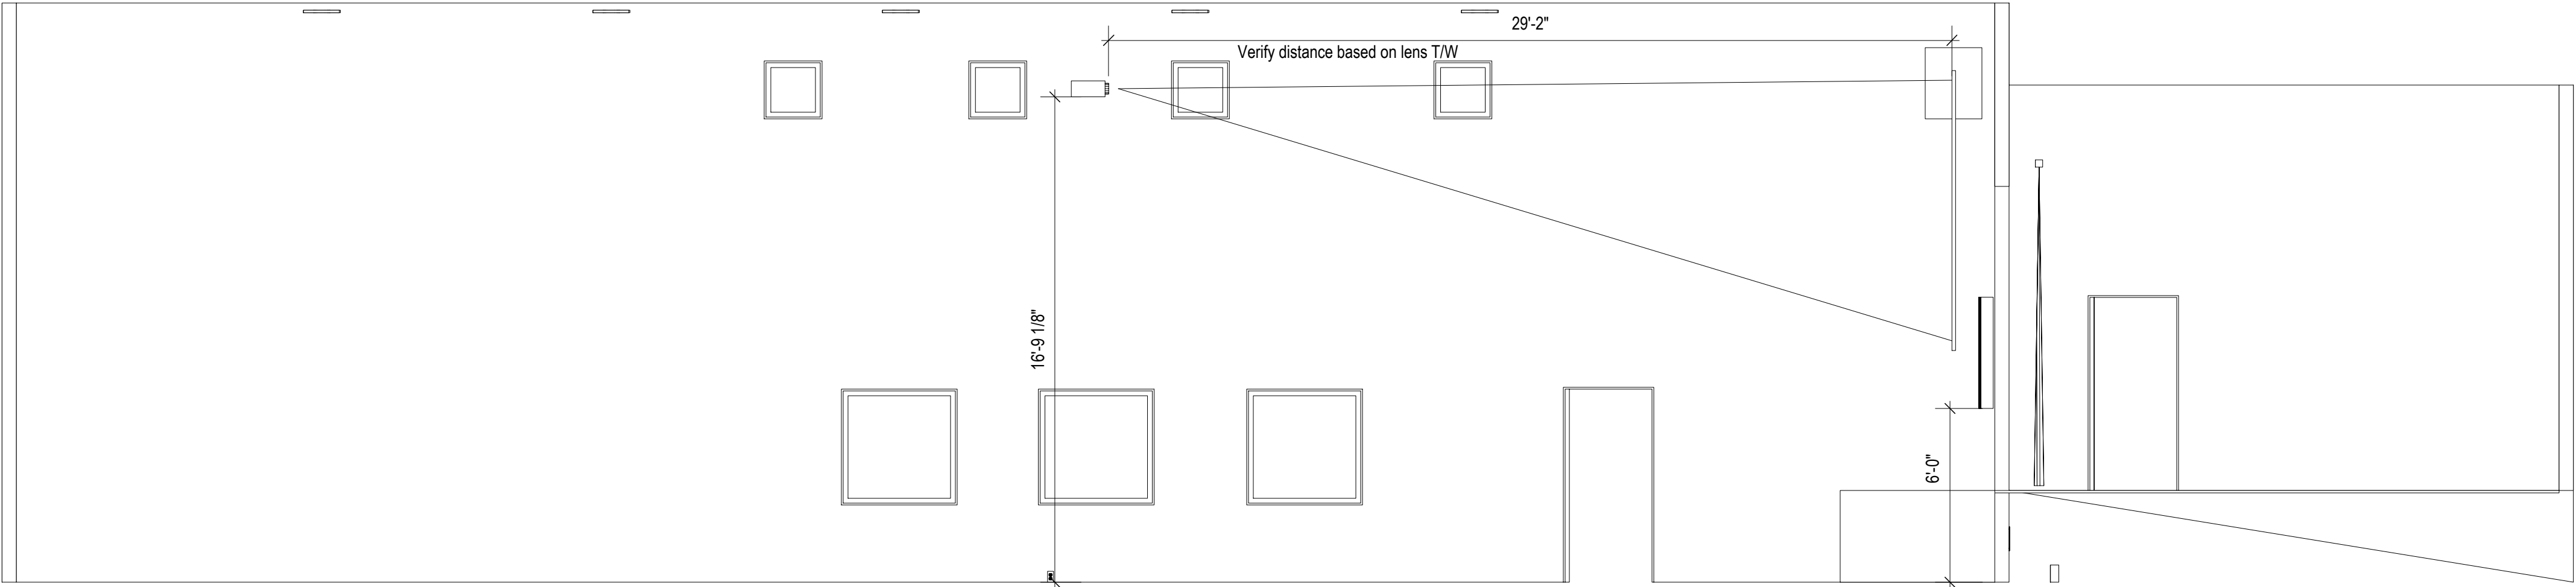


1 AV Section
Scale: 1/4" = 1'-0"

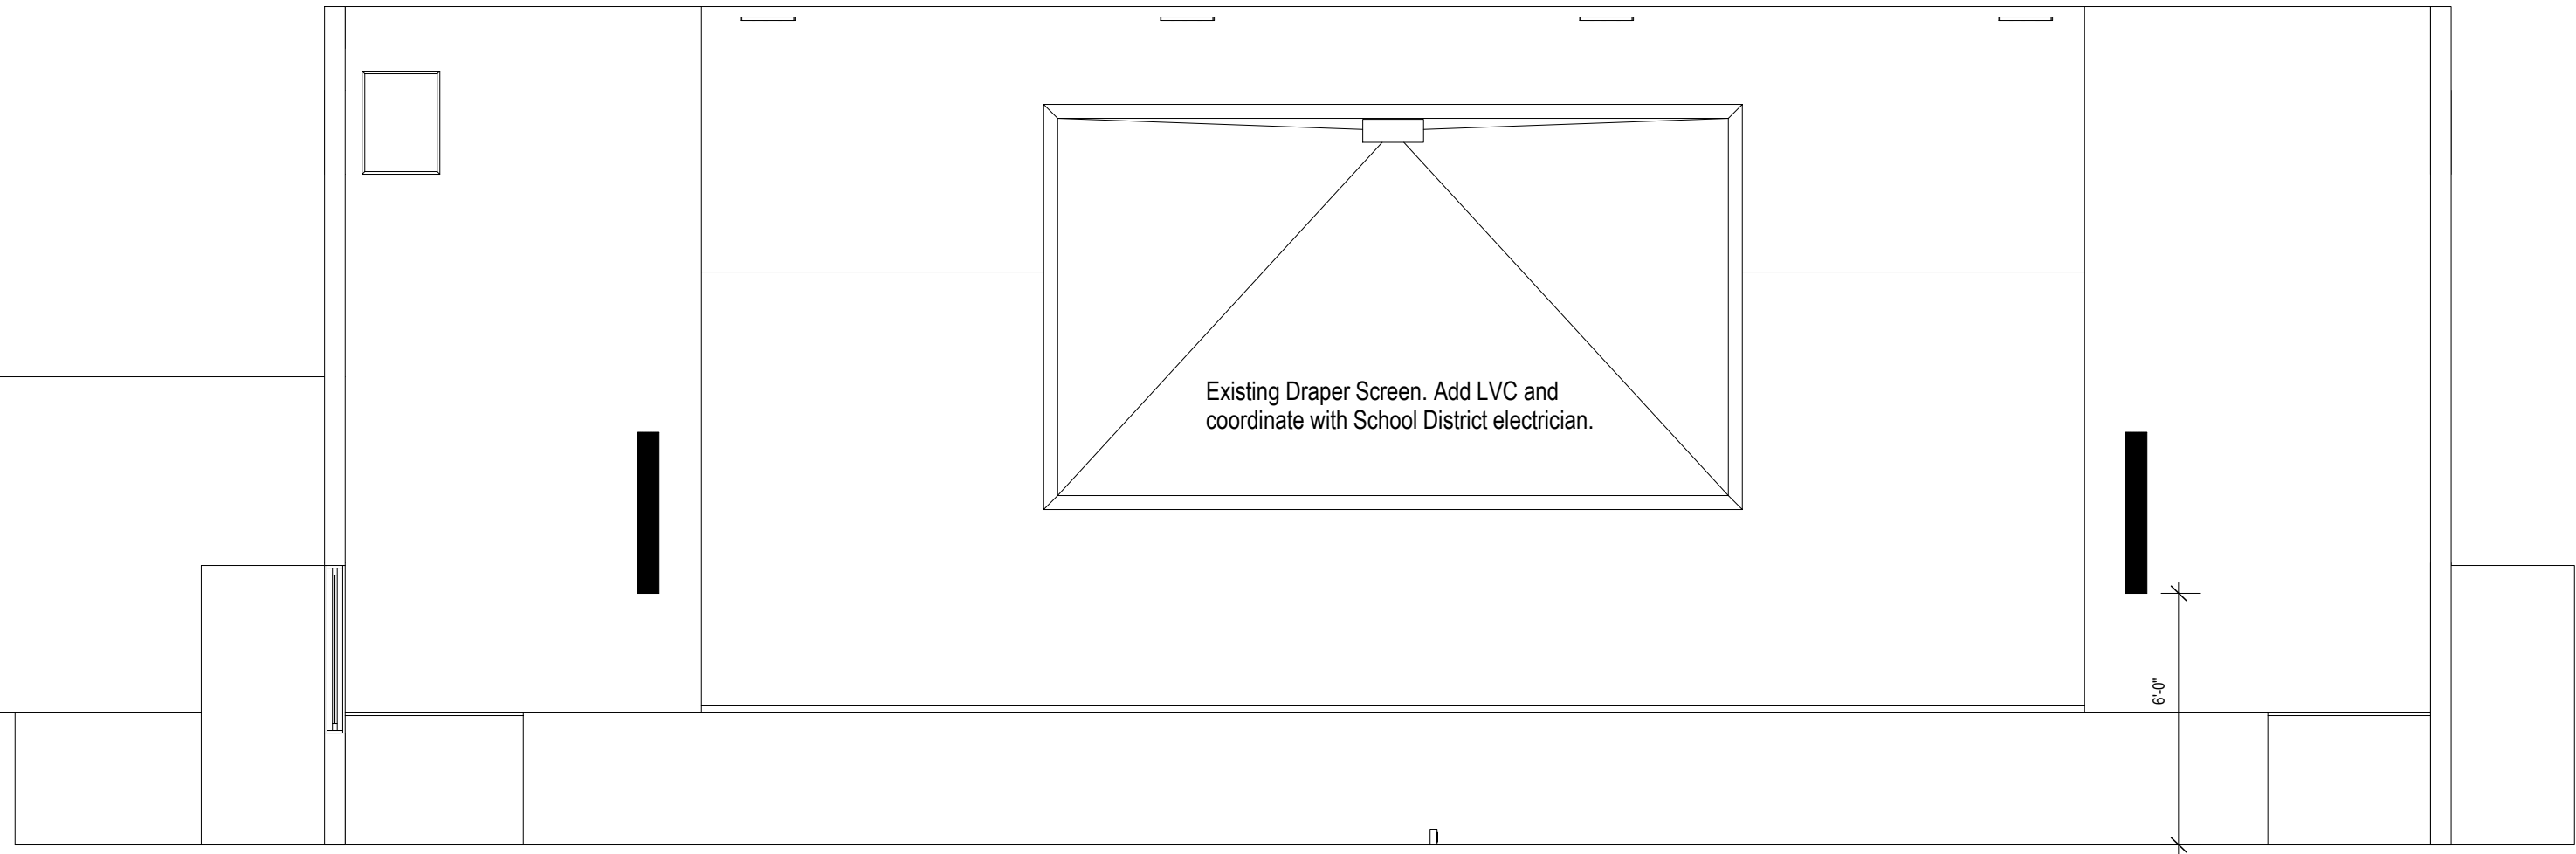


 2 AV Stage Elevation
Scale: 1/4" = 1'-0"



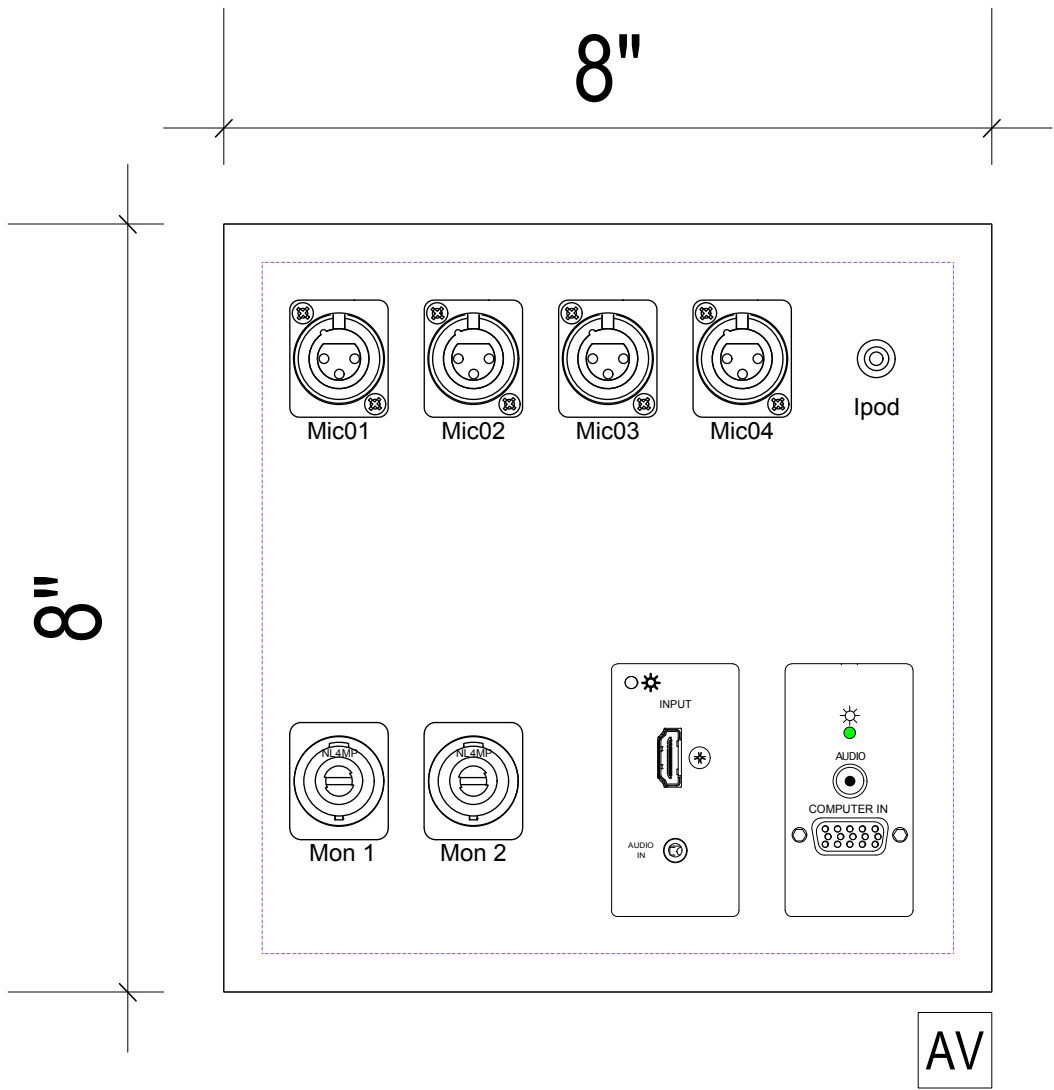

1 Stage AV Plate Detail
Scale: Half Actual Size

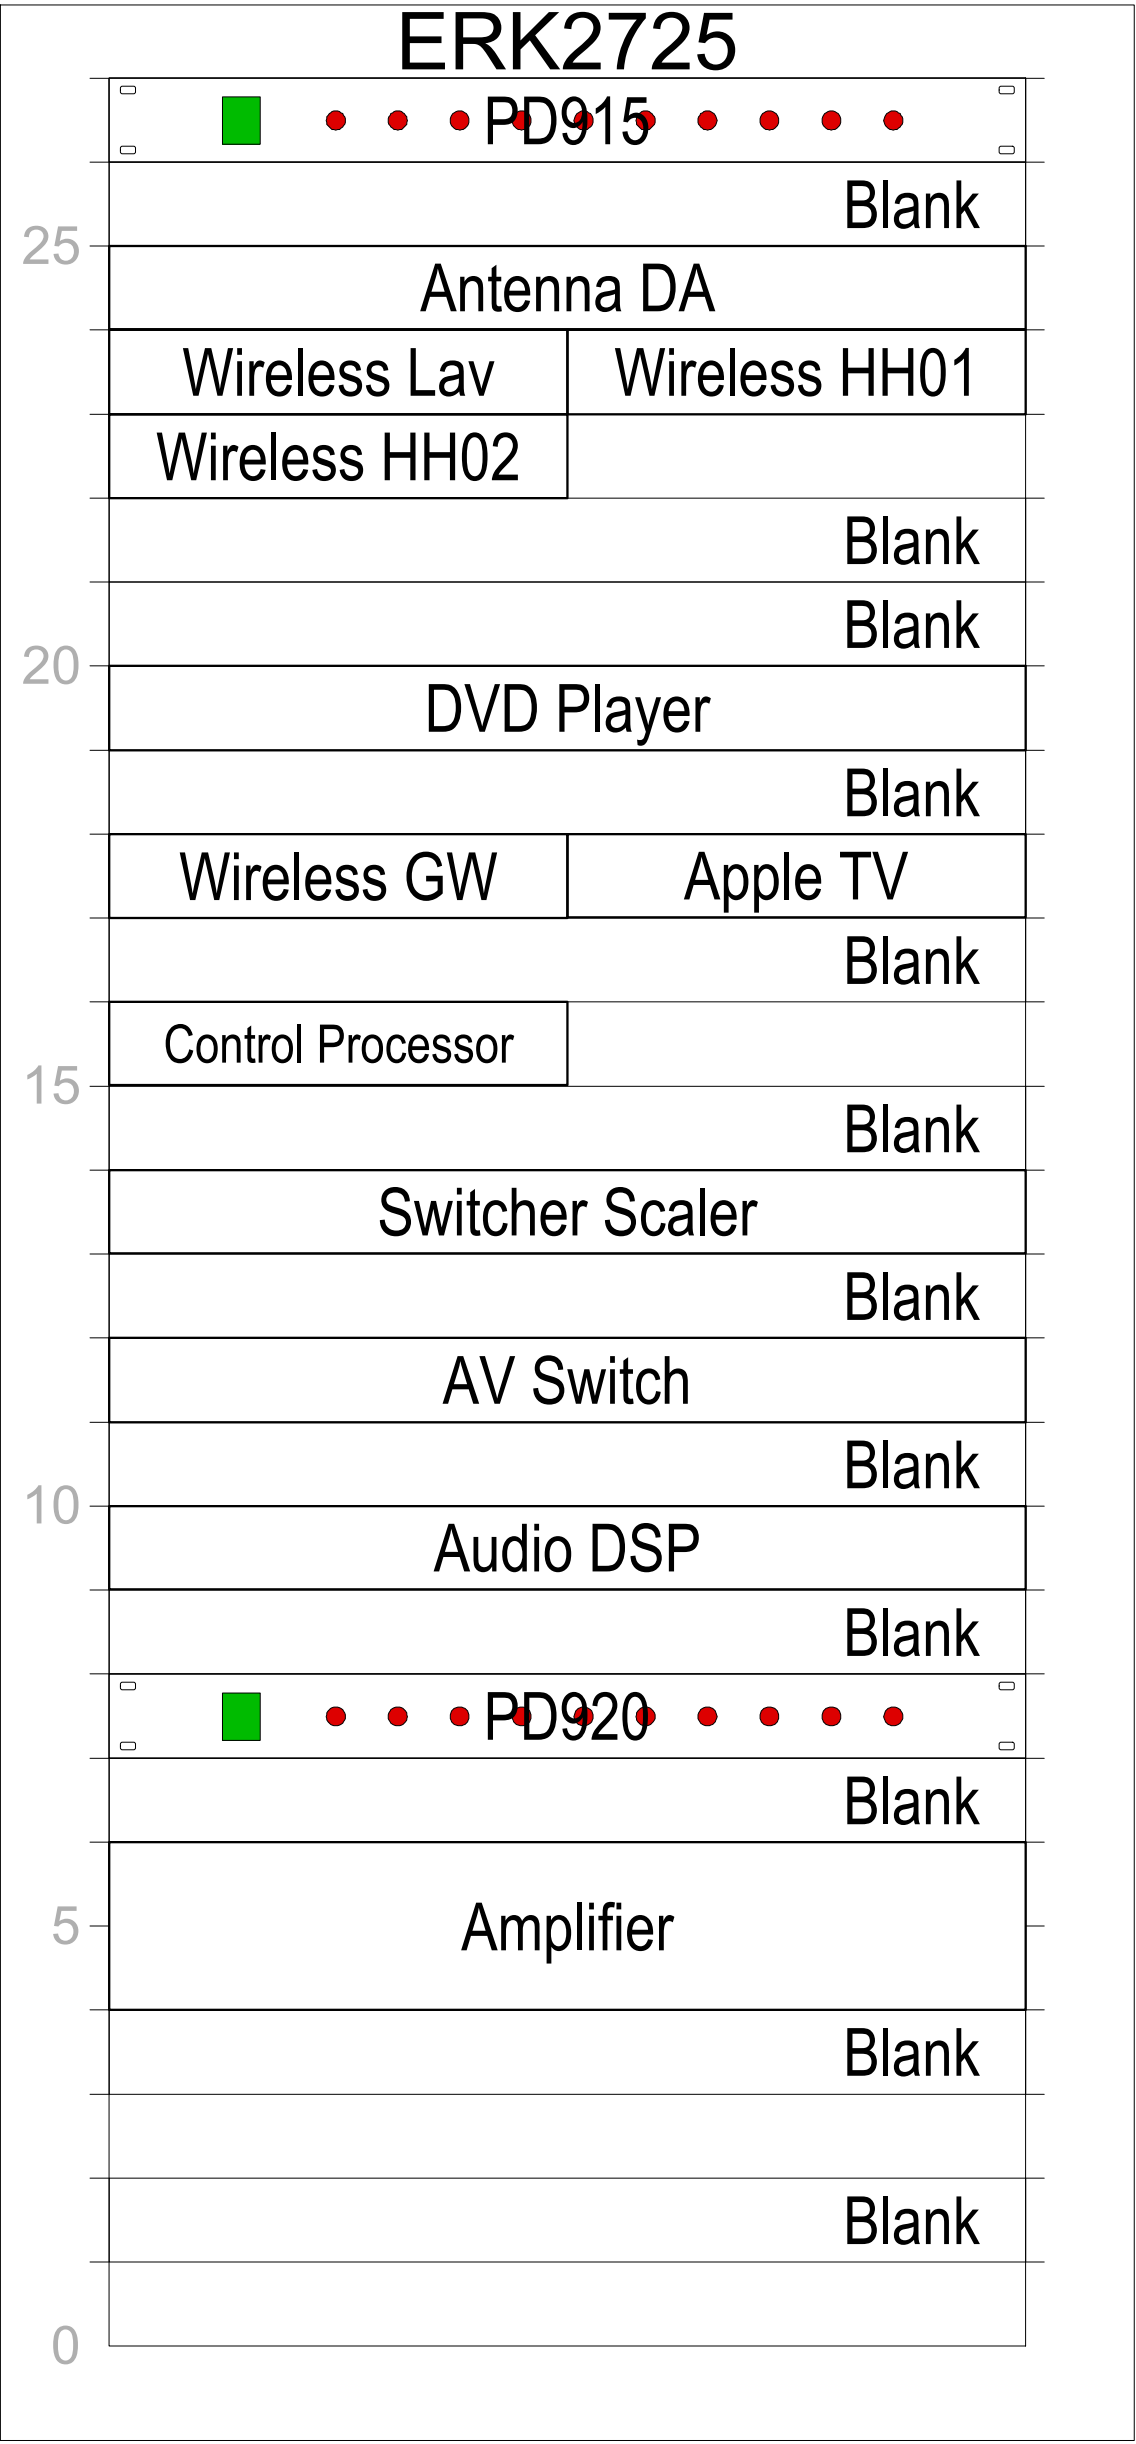

2 AV Rack Detail
Scale: 3" = 1'-0"