

SOUTH BURLINGTON SCHOOL DISTRICT OFFICES

577 DORSET STREET, SOUTH BURLINGTON, VT

PROJECT STATUS NOT FOR CONSTRUCTION
05.19.26

NUMBER	SHEET NAME
ARCHITECTURAL	
A001	GENERAL NOTES
A010	BUILDING AND LIFE SAFETY CODE REVIEW
A013	LIFE SAFETY FIRE AND EGRESS PLANS
A101	SECOND FLOOR PLAN
A410	ENLARGED BATHROOM PLANS AND ELEVATIONS
A411	ENLARGED KITCHEN PLANS AND ELEVATIONS
A412	ENLARGED PLANS AND ELEVATIONS
A500	DOOR SCHEDULE
A600	SECOND FLOOR FINISH PLAN AND SCHEDULE
A700	SECOND FLOOR RCP
P100	SECOND FLOOR DEMO PLAN & DEMO RCP



38 Eastwood Drive
Suite 301
South Burlington, VT 05403
802.655.5020

wla-vt.com

OWNER
SOUTH BURLINGTON SCHOOL DISTRICT
ATTN: JEAN-MAIRE CLARK
577 DORSET STREET
SOUTH BURLINGTON, VT 05403

ARCHITECT
WIEMANN LAMPHERE ARCHITECTS
ATTN: KELLEY DESROCHES
38 EASTWOOD DRIVE, SUITE 301
SOUTH BURLINGTON, VT 05403
802.655.5020

ABBREVIATIONS	
R	DEFINITION
A	
A/C	AIR CONDITIONING
AB	ANCHOR BOLT
ACP	ACOUSTICAL CEILING PANEL
ADA	COMPLIES W/ADA/AG ACCESSIBILITY REQUIREMENTS
AFF	ABOVE FINISH FLOOR
AIB	AIR INFILTRATION BARRIER
ALT	ALTERNATIVE
ALUM / AL	ALUMINUM
APPROX	APPROXIMATE
ARCH	ARCHITECT (URAL)
AVG	AVERAGE
B	
BD	BOARD
BLDG	BUILDING
BLK	BLOCK
BM	BEAM
BM	BENCH MARK
BO	BOTTOM OF
BSMT	BASEMENT
BTM	BOTTOM
BTWN	BETWEEN
C	
CAB	CABINET
CB	CATCH BASIN
CF	CUBIC FEET
CFCI	CONTRACTOR FURNISHED CONTRACTOR INSTALLED
CFOI	CONTRACTOR FURNISHED OWNER INSTALLED
CG	CORNER GUARD
CHALK	CHALKBOARD
CI	CONTINUOUS INSULATION
CIP	CAST IN PLACE
CJ	CONSTRUCTION JOINT / CONTROL JOINT
CL	CENTERLINE
CLG	CEILING
CLO	CLOSET
CLR	CLEAR
CMU	CONCRETE MASONRY UNIT
CO	CLEAN OUT
COL	COLUMN
CONC	CONCRETE
CONST	CONSTRUCTION
CONT	CONTINUE (CONTINUOUS)
COPT	COMMON PATH OF TRAVEL
COR	CORRIDOR
CORR	CORRUGATED
CPT	CARPET
CS	COURSE
CT	CERAMIC TILE
CTR	CENTER
CY	CUBIC YARD
D	
DRL	DOUBLE
DF	DRINKING FOUNTAIN
DIA / Ø	DIAMETER
DIM	DIMENSION
DISP	DISPENSER / DISPLAY
DIV	DIVISION
DN	DOWN
DTL	DETAIL
DWG	DRAWING
E	
E	EAST
EA	EACH
EIFS	EXTERIOR INSULATION FINISH SYSTEM
ELEC	ELECTRIC (AL)
ELEV	ELEVATOR / ELEVATION
ENC	ENCLOSURE / ENCLOSE
ENC	ELECTRICAL PANEL
EP	EQUAL / EQUIPMENT
EQUIP	EQUIPMENT
EW	EACH WAY
EXH	EXHAUST
EXIST	EXISTING
EXP	EXPANSION
EXT	EXTERIOR
F	
FD	FLOOR DRAIN
FG	FIBERGLASS
FO	FINISHED OPENING
FR	FIRE RATE (ED) / FIRE RATING
FT	FOOT
FTG	FOOTING
FURN	FURNITURE
FUT	FUTURE
G	
GA	GAGE / GAUGE
GALV	GALVANIZED
GB	GRAB BAR
GC	GENERAL CONTRACTOR
GFRG	GLASS FIBER REINFORCED CONCRETE
GLAZ	GLAZING
GWB	GYPNUM WALL BOARD
GYP	GYPNUM
H	

ABBREVIATIONS	
R	DEFINITION
H	
HC	HOLLOW CORE
HDR	HEADER
HDW	HARDWARE
HDWD	HARDWOOD
HM	HOLLOW METAL
HORIZ	HORIZONTAL
HP	HORSE POWER
HR	HOUR
HT	HEIGHT
HT	HEAVY TIMBER
HTG	HEATING
HTR	HEATER
HVAC	HEATING, VENTILATING & AIR CONDITIONING
HW	HOT WATER
HYD	HYDRANT
I	
ID	INNER DIAMETER
IN	INCH
INCL	INCLUDE
INSUL / INS	INSULATION
INT	INTERIOR
J	
JC	JANITORS CLOSET
JNT	JOINT
K	
KW	KILOWATT
L	
L	LONG / LENGTH
LAM	LAMINATE
LAV	LAVATORY
LB	POUND
LE	LOW-EXPANSION
LF	LINEAR FOOT
LH	LEFT HAND
LKR	LOCKER
LOC	LOCATION
M	
MAS	MASONRY
MAX	MAXIMUM
MB-X"	MOUNTING BOARD-X"
MECH	MECHANICAL
MEP	MECHANICAL ELECTRICAL & PLUMBING
MFR	MANUFACTURE (R) (ED)
MH	MOP HOLDER
MIN	MINIMUM
MIR	MIRROR
MISC	MISCELLANEOUS
MO	MASONRY OPENING
MRGB	MOISTURE RESISTANT GYPSUM BOARD
MTD	MOUNTED
MTL	METAL
N	
N	NORTH
NA	NOT APPLICABLE
NIC	NOT IN CONTRACT
NO	NUMBER
NOM	NOMINAL
NRC	NOISE REDUCTION COEFFICIENT
NTS	NOT TO SCALE
O	
OC	ON CENTER
OD	OUTER DIAMETER
OFCI	OWNER FURNISHED CONTRACTOR INSTALLED
OFOI	OWNER FURNISHED OWNER INSTALLED
OH	OVERHEAD
OH.DR.	OVERHEAD DOOR
OPNG	OPENING
OPP	OPPOSITE (HAND)
P	
PC	PIECE
PERF	PERFORATED
PH	PHASE / PARTIAL HEIGHT
PL	PROPERTY LINE
PLAM	PLASTIC LAMINATE
PLBG	PLUMBING
PLF	POUNDS PER LINEAR FOOT
PNL	PANEL
PNT	PAINT (ED)
PR	PAIR
PREFIN	PREFINISHED
PROJ	PROJECT
PSF	POUNDS PER SQUARE FOOT
PSI	POUNDS PER SQUARE INCH
PT	PRESSURE PRESERVATIVE TREATED
PTN	PARTITION
PVC	POLYVINYL CHLORIDE
PWD	PLYWOOD
Q	

ABBREVIATIONS	
R	DEFINITION
Q	
QT	QUARRY TILE
R	
R	RADIUS / RISER
RCP	REFLECTED CEILING PLAN
RD	ROOF DRAIN
REF	REFERENCE
REFR	REFRIGERATOR
REINF	REINFORCED
REQ	REQUIRED / REQUIREMENT
RES	RESILIENT
REV	REVISION / REVISE (D) / REVERSE
RM	ROOM
RO	ROUGH OPENING
ROW	RIGHT OF WAY
RTV	ROOF TOP UNIT
S	
S	SOUTH
SAN	SANITARY
SC	SOLID CORE
SCH	SCHEDULE (D)
SECT	SECTION
SF	SQUARE FOOT
SHT	SHEET
SIM	SIMILAR
SPEC	SPECIFICATION
SO	SQUARE
SS	STAINLESS STEEL
STC	SOUND TRANSMISSION CLASS
STD	STANDARD
STL	STEEL
STO	STORAGE
STRUCT	STRUCTURAL / STRUCTURE
SUSP	SUSPENSION
SY	SQUARE YARD
SYM	SYMMETRICAL
SYN	SYNTHETIC
T	
T	TREAD
T&G	TONGUE AND GROOVE
TEL	TELEPHONE
TEMP	TEMPORARY
TERM	TERMINATE
THRU	THROUGH
TLT	TOILET
TO	TOP OF
TOC	TOP OF CURB / CONCRETE
TOW	TOP OF WALL
TV	TELEVISION
TYP	TYPICAL
U	
UG	UNDERGROUND
UH	UNIT HEATER
UL	UNDERWRITERS LABORATORIES
UNO	UNLESS NOTED OTHERWISE
UR	URINAL
US	URINAL SCREEN
V	
VCT	VINYL COMPOSITION TILE
VERT	VERTICAL
VEST	VESTIBULE
VIF	VERIFY IN FIELD
VR	VAPOR RETARDER
W	
W	WEST
W/	WITH
W/O	WITHOUT
WC	WATER CLOSET
WD	WOOD
WH	WATER HEATER
WRAB	WEATHER RESISTANT AIR BARRIER
WRB	WEATHER RESISTANT BARRIER
WT	WEIGHT
Y	
Y	YARD

EXISTING BUILDING GENERAL NOTES:

- DIMENSIONS
 - VERIFY ALL DIMENSIONS AND CONDITIONS. NOTIFY ARCHITECT FOR CLARIFICATION OF ANY DISCREPANCIES PRIOR TO PROCEEDING WITH THE WORK.
- CONTRACTOR TO FIELD VERIFY EXISTING ROOF PITCH(ES) MATCH THOSE INDICATED WITHIN DRAWING SET.
- COORDINATE AND ALIGN NEW WALL FINISHES WHERE ABUTTING EXISTING CONDITIONS UNLESS OTHERWISE NOTED.
- ALL WORK SHALL CONFORM TO APPLICABLE SAFETY AND BUILDING CODES, LABOR LAWS, AND ORDINANCES.
- DO NOT SCALE DRAWINGS:
 - THE CONTRACTOR SHALL USE DIMENSIONS SHOWN ON THE DRAWINGS AND ACTUAL FIELD MEASUREMENTS. NOTIFY THE ARCHITECT FOR CLARIFICATION IF ANY DISCREPANCIES ARE FOUND.
- ABBREVIATIONS:
 - COMMON-USE ABBREVIATIONS ARE USED THROUGHOUT THE DRAWINGS. THE ABBREVIATIONS LIST IS NOT INTENDED TO BE COMPLETE OR REPRESENT CONDITIONS OR MATERIALS USED IN THE PROJECT. REQUEST ARCHITECT CLARIFICATION FOR ANY ABBREVIATIONS IN QUESTION.
- THE DRAWINGS AND SPECIFICATIONS:
 - PLUMBING, MECHANICAL AND ELECTRICAL DRAWINGS ARE SUPPLEMENTARY TO THE ARCHITECTURAL DRAWINGS. IT SHALL BE THE RESPONSIBILITY OF THE CONTRACTOR TO CHECK WITH THE ARCHITECTURAL DRAWINGS BEFORE THE INSTALLATION OF THEIR WORK. ANY DISCREPANCY BETWEEN THE ARCHITECTURAL AND THE CONSULTING ENGINEER(S) DRAWINGS SHALL BE BROUGHT TO THE ARCHITECTS ATTENTION BY WRITTEN REQUEST FOR CLARIFICATION. ANY WORK INSTALLED IN CONFLICT WITH THE ARCHITECTURAL DRAWINGS SHALL BE CORRECTED BY THE CONTRACTOR AT HIS OWN EXPENSE AND AT NO EXPENSE TO THE OWNER OR ARCHITECT.
- COORDINATIONS:
 - THE CONTRACTOR SHALL BE RESPONSIBLE FOR VERIFICATIONS AND THE COORDINATION OF THE WORK TO ASSURE COMPLIANCE WITH THE DRAWINGS AND SPECIFICATIONS, AND THE ACCURATE LOCATION OF STRUCTURAL MEMBERS AND OPENINGS FOR MECHANICAL.
 - THE CONTRACTOR SHALL VERIFY SIZES AND LOCATIONS OF ALL OPENINGS FOR EQUIPMENT WITH MECHANICAL AND ELECTRICAL SUBCONTRACTOR(S) BEFORE PROCEEDING WITH THE WORK.
 - THE CONTRACTOR SHALL VERIFY SIZES AND LOCATIONS OF ALL EQUIPMENT PADS AND BASES AS WELL AS POWER AND WATER OR DRAIN INSTALLATION WITH EQUIPMENT MANUFACTURERS BEFORE PROCEEDING WITH THE WORK.
- PARTITIONS SHALL BE FULL HEIGHT ASSEMBLY TO FLOOR OR ROOF DECK ABOVE, UNLESS NOTED OTHERWISE.
- FINISHED FLOOR ELEVATION IS TOP OF CONCRETE SLAB OR SUB-FLOOR.
- WHEN CONTENT EXISTS IN MULTIPLE LOCATIONS, THE VIEW WITH THE LARGEST SCALE SUPERCEDES ALL VIEWS OF A SMALLER SCALE.


ARCHITECTURAL LEGEND

	PLYWOOD		UNDISTURBED OR COMPACTED SOIL
	BLOWN-IN INSULATION (DENSE) PRODUCT. SEE SPECIFICATIONS		CONCRETE
	BLOWN-IN INSULATION (LOOSE) PRODUCT. SEE SPECIFICATIONS		BRICK
	BATT INSULATION PRODUCT. SEE SPECIFICATIONS		CONCRETE MASONRY UNIT
	ABOVE GRADE BOARD INSULATION PRODUCT. SEE SPECIFICATIONS		MILLWORK
	BELOW GRADE BOARD INSULATION PRODUCT. SEE SPECIFICATIONS		GYPNUM CEILING BOARD
	ROOF INSULATION PRODUCT. SEE SPECIFICATIONS		GYPNUM WALL BOARD
	SPRAY FOAM PRODUCT. SEE SPECIFICATIONS		GRAVEL
			EAVE PROTECTION MEMBRANE

AIR CONTROL LAYERS LEGEND


WEATHER RESISTANT BARRIER (WRB)	
VARIABLE VAPOR RETARDER (VVR)	
ROOF VAPOR BARRIER (RVB)	
UNDERSLAB VAPOR BARRIER (UVB)	
WATERPROOFING MEMBRANE (WPM)	
CEILING VAPOR BARRIER (CVB)	
FLEXIBLE FLASHING WEATHER BARRIER (FFWB)	

MISC. ARCHITECTURAL SYMBOLS

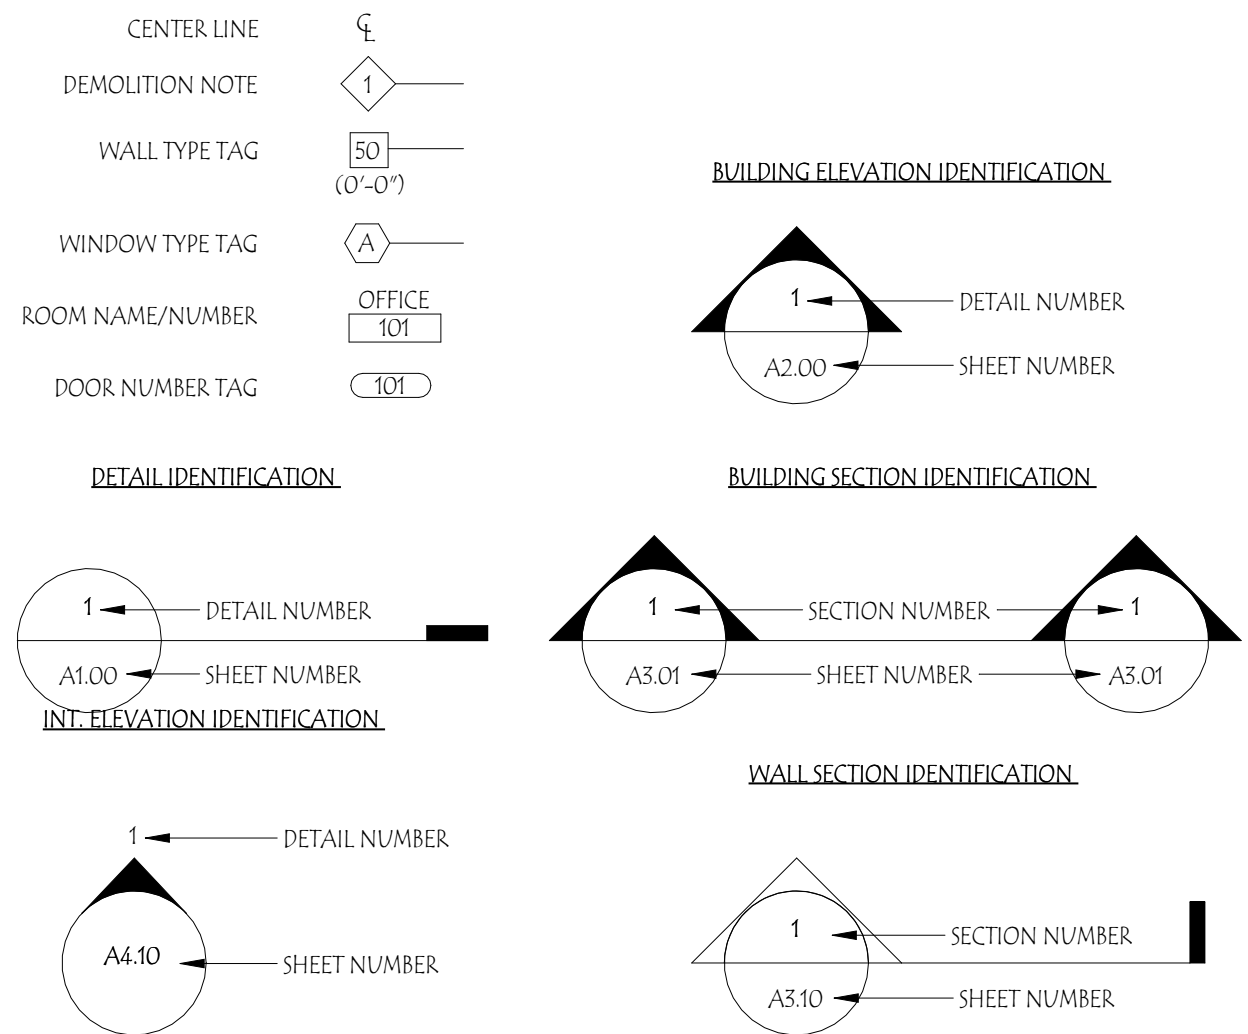

- WALLS AND PARTITIONS SHALL BE FULL HEIGHT (INCLUDING FINISHES) TO FLOOR OR ROOF DECK ABOVE, UNLESS NOTED OTHERWISE.
- REFERENCE STRUCTURAL DRAWINGS FOR STUD SPACING, TYPICAL.
- REFERENCE SPECIFICATION(S) AND STRUCTURAL DRAWINGS FOR CFS DESIGN, TYPICAL.
- PROVIDE MOISTURE RESISTANT GYPNUM (MRGB) IN ALL TOILET AND BATHROOM LOCATIONS UNLESS NOTED OTHERWISE.

GENERAL NOTES - WALL AND PARTITIONS

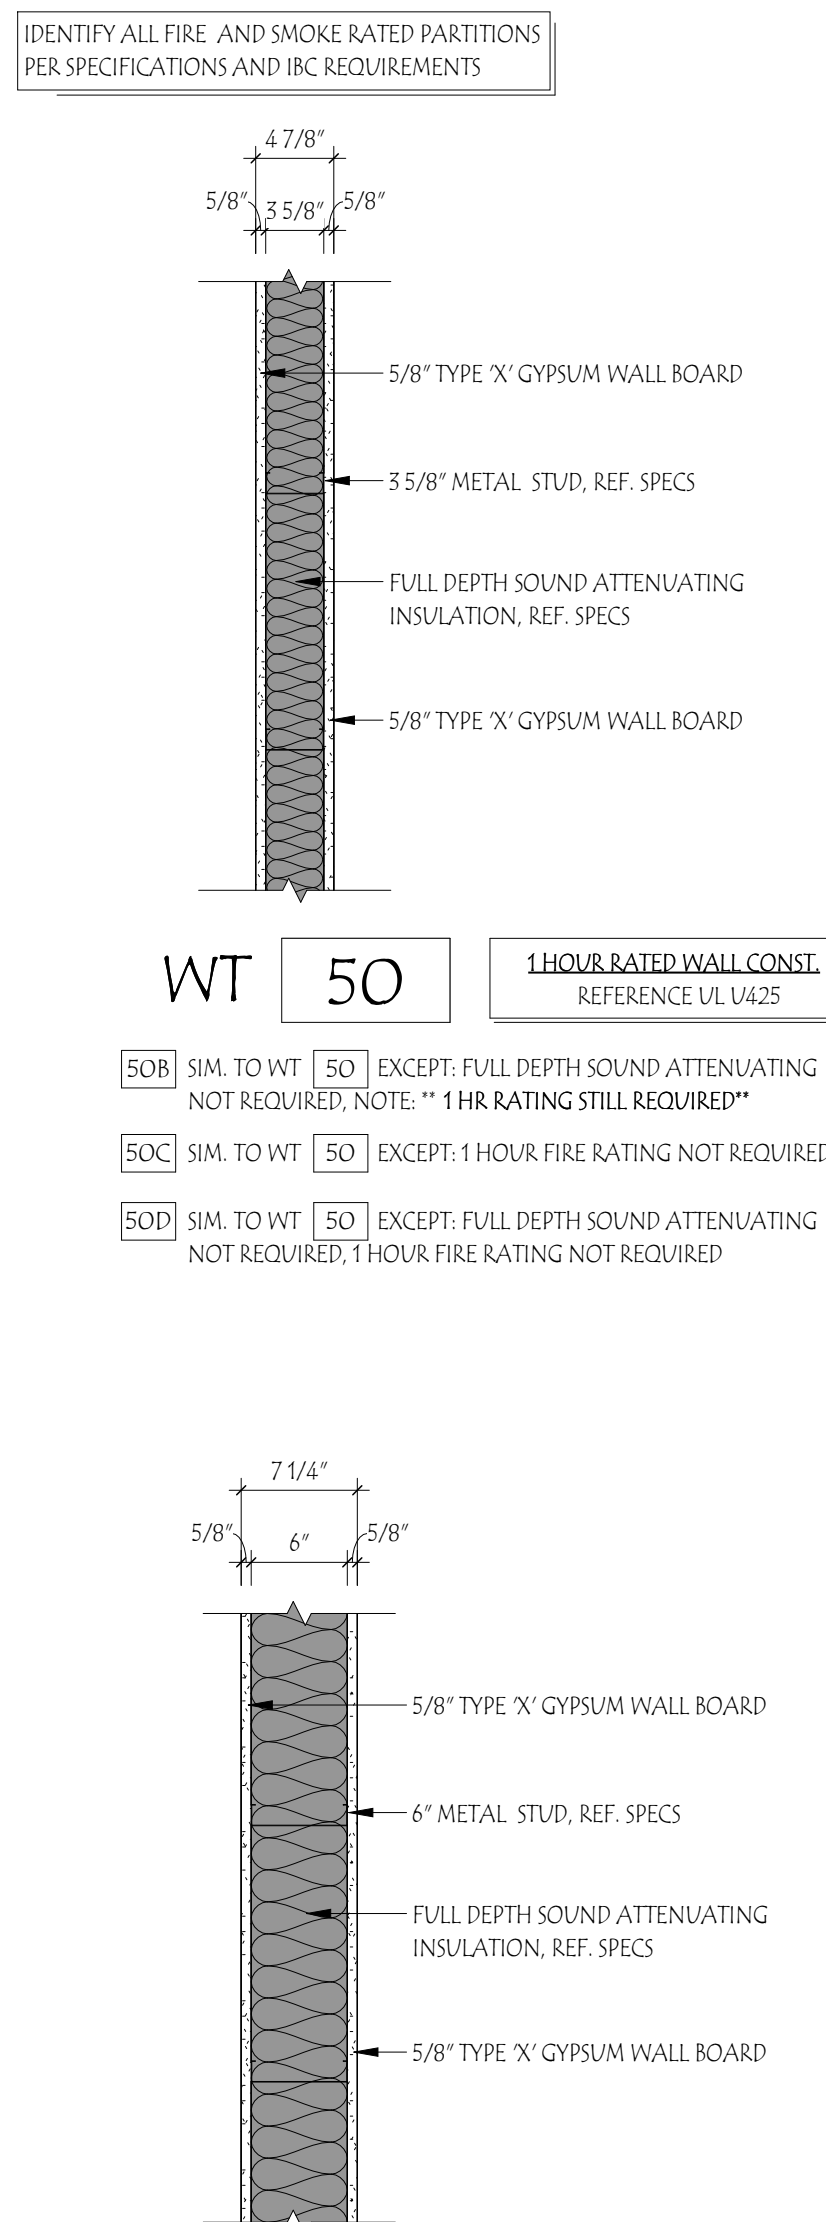

- 52B SIM. TO WT 52 EXCEPT: FULL DEPTH SOUND ATTENUATING NOT REQUIRED; NOTE: "1 HR RATING STILL REQUIRED"
- 52C SIM. TO WT 52 EXCEPT: 1 HOUR FIRE RATING NOT REQUIRED
- 52D SIM. TO WT 52 EXCEPT: FULL DEPTH SOUND ATTENUATING NOT REQUIRED; 1 HOUR FIRE RATING NOT REQUIRED



38 Eastwood Drive
Suite 301
South Burlington, VT 05403
802.655.5020

wla-vt.com

OWNER
SOUTH BURLINGTON SCHOOL DISTRICT
ATTN: JEAN-MAIRE CLARK
577 DORSET STREET
SOUTH BURLINGTON, VT 05403

ARCHITECT
WIEMANN LAMPHERE ARCHITECTS
ATTN: KELLEY DESROCHES
38 EASTWOOD DRIVE, SUITE 301
SOUTH BURLINGTON, VT 05403
802.655.5020

PROJECT STATUS
NOT FOR CONSTRUCTION

DATE REVISION DESCRIPTION

SOUTH BURLINGTON SCHOOL DISTRICT OFFICES

SOUTH BURLINGTON, VERMONT

GENERAL NOTES

PROJECT NO: 2026015
PROGRESS PRINT: 5/19/2026 11:07:41 AM
CHECKED BY: KD
DRAWN BY: KRL/CG
SCALE: As indicated

A001

FILENAME: C:\Users\Nikolai\Documents\2026015_026_ARCH_5850 OFFICES_ARCH_10404\N03XX.r PRINTED: 5/19/2026 11:07:42 AM

PROJECT SUMMARY:

RENOVATION OF EXISTING SCHOOL DISTRICT OFFICES INTO CLASSROOMS, LEVEL TWO. ALL OTHER OCCUPANCIES TO REMAIN AS IS.

APPLICABLE CODES STATE OF VERMONT:

☒ VERMONT FIRE & BUILDING SAFETY CODE, 2025 EDITION (VFBS)

☒ NFPA 1 – UNIFORM FIRE CODE w/ VT AMENDMENTS, 2021 EDITION (NFPA1)☒ NFPA 101 – LIFE SAFETY CODE w/ VT AMENDMENTS, 2021 EDITION (NFPA101)☒ NFPA 70 – NATIONAL ELECTRICAL CODE w/ VT AMENDMENTS, 2023 EDITION☒ INTERNATIONAL BUILDING CODE w/ VT AMENDMENTS, 2021 EDITION (IBC)☒ INTERNATIONAL PLUMBING CODE w/ VT AMENDMENTS, 2024 EDITION (IPC)

☐ VERMONT COMMERCIAL BUILDING ENERGY STANDARDS, 2024 EDITION (CBES)☐ VERMONT RESIDENTIAL BUILDING ENERGY STANDARDS, 2024 EDITION (RBES)☒ VERMONT ACCESS RULES, 2012 EDITION (VAR)

☒ AMERICANS WITH DISABILITIES ACT w/ VT AMENDMENTS, 2010 EDITION (ADA)☐ CIVIL RIGHTS ACT OF 1968 (AKA FAIR HOUSING ACT), AMENDED 1988 (FHA)

PROJECT TYPE:

☐ NEW CONSTRUCTION

☐ MAJOR REHABILITATION, MODIFICATION, RECONSTRUCTION

☐ BUILDING ADDITION

☒ EXISTING BUILDING WITH CHANGE OF USE / RENOVATION

ADDITIONAL APPLICABLE CODES PER PROJECT TYPE:

☒ IBCC (*STRUCTURAL ONLY*)☒ NFPA 101 CHAPTER 43☒ NFPA 220

BUILDING OCCUPANCY: NFPA 101 USE CHAPTERS & IBC SECTION 303			
NFPA OCCUPANCY	NFPA CHAPTER	IBC OCCUPANCY	IBC SECTION
EXISTING EDUCATIONAL	CH. 15	(E) EDUCATIONAL	305
EXISTING BUSINESS	CH. 39	(B) BUSINESS	304
EXISTING ASSEMBLY	CH. 13	(A) ASSEMBLY	303
EXISTING STORAGE			
SINGLE OCCUPANCY:	☐ YES ☒ NO		
IBC MIXED USE OCCUPANCY:	☒ YES ☐ NO	☐ SEPARATED ☒ NON-SEPARATED	
NFPA MULTIPLE OCCUPANCY:	☒ YES ☐ NO	☐ SEPARATED ☒ MIXED	
IF MIXED USE, NON-SEPARATED OCCUPANCY, REQUIREMENTS OF THE MOST STRICT OCCUPANCY TYPE WILL APPLY TO: BUILDING HEIGHT & AREA, AND MEANS OF EGRESS.			

CLASSIFICATION OF HAZARDOUS CONTENTS: NFPA 101 SECTION 6.2.2

☐ LOW

☒ ORDINARY

☐ HIGH

CONSTRUCTION TYPE: IBC CHAPTER 6, TABLE 601 & NFPA 101 SECTION 8.2.2

2B

☐ I (442) = IBC 1A☐ II (222) = IBC 1B☐ II (111) = IBC 2A☒ II (000) = IBC 2B☐ III (211) = IBC 3A

☐ III (200) = IBC 3B☐ IV (2HH) = IBC 4HT☐ V (111) = IBC 5A☐ V (000) = IBC 5B

NFPA 285 COMPLIANCE:

♦ TYPE 1, 2, 3, OR 4 CONSTRUCTION TYPE?

☒ YES☐ NO

♦ FOAM PLASTIC INSULATION IN EXTERIOR WALLS?

♦ ONE STORY BUILDING

♦ BUILDING IS EQUIPPED WITH AN AUTOMATIC SPRINKLER SYSTEM

♦ FLAME SPREAD INDEX IS 25 OR LESS

♦ SMOKE DEVELOPMENT RATING IS 450 OR LESS

♦ FOAM THICKNESS IS 4" OR LESS

♦ ALUM CLADDING MIN .052"

♦ STEEL CLADDING MIN .060"

☒ YES☐ NO

♦ IS CLADDING COMBUSTIBLE AND 40FT ABOVE GRADE?

☐ YES☒ NO

♦ IS W.R.B. COMBUSTIBLE AND 40FT ABOVE GRADE?

☐ YES☒ NO

♦ IS NFPA 285 COMPLIANCE REQUIRED FOR PROJECT:

☐ YES☒ NO

FIRE RESISTANCE RATINGS: IBC TABLE 601 / NFPA 220		
BUILDING ELEMENTS		
	RATING	NFPA SECTION
PRIMARY STRUCTURAL FRAME	0 HR	–
EXTERIOR BEARING WALLS	0 HR	–
INTERIOR BEARING WALLS	0 HR	–
NON BEARING EXTERIOR WALLS	0 HR	4.3.2.12
NON BEARING INTERIOR WALLS	0 HR	4.3.2.11
FLOOR	0 HR	–
ROOF	0 HR	–

FIRE PROTECTION REQUIREMENTS NFPA 101 CHAPTER 8 & NFPA USE CHAPTERS

ACCESSORY USE AREAS:

–

EGRESS / EXIT ENCLOSURE SEPARATIONS:

–

VERTICAL OPENING SEPARATIONS:

–

FIRESTOPPING:

SHALL COMPLY WITH GOVERNING CODES TO THAT THE REQUIRED RATING OF AN ASSEMBLY IS NOT REDUCED OR ELIMINATED BY PENETRATIONS. IN GENERAL, FIRESTOPPING IS REQUIRED WHEREVER:

♦ PENETRATIONS OCCUR THROUGH FIRE RESISTANCE RATED ASSEMBLIES BY BUILDING SERVICE LINES SUCH AS PIPING, DUCTWORK, CONDUIT, ETC.

♦ JOINTS OCCUR IN OR VOIDS/GAPS OCCUR AROUND FIRE-RATED ASSEMBLIES.

♦ AIR PASSAGES ARE CONCEALED OR PASS VERTICALLY THROUGH FLOORS, SUCH AS SHAFTS, CEILING PLENUMS AND MECHANICAL ELECTRICAL, POWER AND COMMUNICATION CHASES.

♦ CONCEALED SPACES WITH DRAFTSTOPPING EVERY 3,000 SQUARE FEET UNLESS THE BUILDING IS SPRINKLED.

♦ PLENUMS CONCEALED WITHIN A FLOOR ASSEMBLY MUST BE FIRESTOPPED OVER/UNDER PERMANENT WALLS AND OTHERWISE TO LIMIT CLEAR-OPEN SPACES TO 100 SQUARE FEET.

NOTE: ANY AND ALL PENETRATION THAT PASS THROUGH A RATED ASSEMBLY MUST BE FIRE STOPPED BY MEANS OF A LISTED ASSEMBLY TO STOP THE SPREAD OF HEAT AND SMOKE PER NFPA 101:8.3.5 (2015 EDITION)

CONTRACTORS AND SUB-CONTRACTORS ARE REQUIRED TO HAVE CUT SHEETS OF FIRESTOPPING ASSEMBLIES AVAILABLE FOR REVIEW AND APPROVAL BY THE DIVISION OF FIRE SAFETY.

OCCUPANT LOAD NFPA 101 TABLE 7.3.1.2 EGRESS / IBC TABLE 1004.1.2 PLUMBING			
OCCUPANT LOAD (NFPA TABLE 7.3.1.2)			
USAGE	AREA	LOAD FACTOR	OCCUPANCY LOAD
LEVEL 1			
ASSEMBLY	2,088 SF	50	42
BUSINESS	11,488 SF	150	77
STORAGE	5,257 SF	200	27
LEVEL 2			
BUSINESS (S)	4,885 SF	150	34
EDUCATIONAL	1,226 SF	20	64
	24,922 SF		244
OCCUPANT LOAD CATEGORIES REFER TO ACTUAL USE OF SPACE, NOT OCCUPANCY "TYPE" (REFER TO NFPA TABLE 7.3.1.2)			

FIRE PROTECTION SYSTEMS NFPA 101 CHAPTER 7 & USE GROUP CHAPTER PROVISIONS

FIRE ALARM:

☒ EXISTING TO REMAIN

☐ NEW CO ALARM

☐ NEW MANUAL

☐ NEW SINGLE STATION SMOKE

☐ NEW AUTOMATIC DETECTION

SPRINKLER SYSTEM:

☐ EXISTING TO REMAIN

☐ NONE

☒ NEW AUTOMATIC/SUPERVISED

☐ NFPA 13☐ NFPA 13R☐ FM-200

☐ NEW FIRE PUMP

☐ NEW STANDPIPE(S)

☐ NEW FIRE DEPARTMENT CONNECTION

PORTABLE FIRE EXTINGUISHER REQUIREMENTS:

☒ PORTABLE FIRE EXTINGUISHERS

RATING PROVIDED

CLASS A:

☒ 2A☐ 4A☐ 10A

TRAVEL DISTANCE: ☐ 30FT☐ 50FT☒ 75FT

CLASS BC:

☐ 5BC☐ 10BC☒ 20BC

TRAVEL DISTANCE: ☐ 30FT☒ 50FT☐ 75FT

CLASS K:

☒ K

TRAVEL DISTANCE: ☒ 30FT☐ 50FT☐ 75FT

EGRESS REQUIREMENTS NFPA 101 CHAPTER 7 & USE GROUP CHAPTER PROVISIONS

** SEE LIFE SAFETY PLANS FOR DETAILS **

EXIT REMOTENESS – 7.5.1.3

☐ 1/2 DIAGONAL DISTANCE (7.5.1.3.2)☒ 1/3 DIAGONAL DISTANCE (7.5.1.3.3)

NUMBER OF MEANS OF EGRESS EXITS – 7.4.1.1

☒ BY LEVEL REQUIREMENT = 2☐ SPECIAL USE GROUP REQUIREMNT =☐ SPECIAL EXEMPTION =

EGRESS COMPONENT SIZING & CAPACITY (LEVEL 2 ONLY): NFPA 101 CHAPTER 7 & USE CHAPTERS

STAIRS / RAMPS

DOORS

CORRIDORS

EGRESS COMPONENT ARRANGEMENT (LEVEL 2 ONLY): NFPA 101 CHAPTER 7 & USE CHAPTERS

OCCUPANCY	TRAVEL DISTANCE TO EXIT (TDE)		COM PATH OF TRAVEL (CPOT)		DEAD END CORRIDOR (DEC)	
	ALLOWED	PROVIDED	ALLOWED	PROVIDED	ALLOWED	PROVIDED
– BUSINESS	300'-0"	57'-1"	100'-0"	40'-0"	50'	N/A
– EDUCATIONAL	150'-0"	48'-10"	100'-0"	40'-0"	50'	N/A
–	–	–	–	–	–	–
–	–	–	–	–	–	–

INTERIOR FINISHES NFPA 101 SECTION 10.2			
OCCUPANCY:	EXITS	EXIT ACCESS CORRIDORS	OTHER SPACES
– BUSINESS	– CLASS A OR B	– CLASS A OR B	– CLASS A, B, OR C
– EDUCATIONAL	– CLASS A	– CLASS A OR B	– CLASS A OR B
–	–	–	–
♦ NFPA 101 10.2.8: IF BLDG IS SPRINKLERED, CLASS C ALLOWED WHERE CLASS B IS REQUIRED. CLASS B ALLOWED WHERE CLASS A IS REQUIRED. TYPE II IS ALLOWED WHERE TYPE I IS REQUIRED. ♦ IN MULTIPLE OCCUPANCY, MIXED, MOST STRICT REQUIREMENTS GOVERN. ♦ A, B, & C DENOTE INTERIOR WALL & CEILING FINISH RATING REQUIREMENTS PER ASTM E84 / UL 723. ♦ I & II DENOTE INTERIOR FLOOR FINISH RATING REQUIREMENTS PER NFPA 255.			

PLUMBING FIXTURES IBC CHAPTER 29 SECTION 2902.1

OCCUPANCY	# OF OCCUPANTS			WATER CLOSETS			LAVATORIES		DRINKING FOUNTAIN	SERVICE SINK
	TOTAL MALE	TOTAL FEMALE	TOTAL	TOTAL MALE	TOTAL FEMALE	TOTAL	TOTAL MALE	TOTAL FEMALE		
L2 BUSINESS – B	17	17	34	.68	.68		.425	.425	0.07	–
L2 EDUCATIONAL – E	32	32	64	.64	.64		.64	.64	0.128	–
TOTAL REQUIRED				1.32 = 2	1.32 = 2	4	1.01 = 1	1.01 = 1	4	1.24 = 2
PROVIDED				–	–	3*	–	–	3*	1

PLUMBING FIXTURE OCCUPANCY REFER TO OCCUPANCY "TYPE" (REFER TO IBC CH. 10, SECT 1004.1.2)

*THE TENANT WHO WILL BE OCCUPYING THIS SPACE IS AN ALTERNATIVE THERAPY PROGRAM FOR STUDENTS WITH SPECIAL NEEDS WHICH ALTHOUGH EDUCATIONAL, THE OCCUPANCY COUNT FOR THE SPACE IS MUCH LESS THAN A TYPICAL CLASSROOM OCCUPANCY. AHJ TO REVIEW IF ALTERNATIVE CODE COMPLIANCE FOR 3 WATER CLOSETS INSTEAD OF 4 IS ACCEPTABLE.

WLA

38 Eastwood Drive
Suite 301
South Burlington, VT 05403
802.655.5020

wla-vt.com

OWNER
SOUTH BURLINGTON SCHOOL DISTRICT
ATTN: JEAN-MAIRE CLARK
577 DORSET STREET
SOUTH BURLINGTON, VT 05403

ARCHITECT
WIEMANN LAMPHERE ARCHITECTS
ATTN: KELLEY DESROCHES
38 EASTWOOD DRIVE, SUITE 301
SOUTH BURLINGTON, VT 05403
802.655.5020

PROJECT STATUS
NOT FOR CONSTRUCTION

#	DATE	REVISION DESCRIPTION
---	------	----------------------

SOUTH BURLINGTON SCHOOL DISTRICT OFFICES

SOUTH BURLINGTON, VERMONT

BUILDING AND LIFE SAFETY CODE REVIEW


PROJECT NO: 2026015
PROGRESS PRINT: 5/19/2026 11:07:42 AM
CHECKED BY: KD
DRAWN BY: KRL/CG
SCALE: 1/4" = 1'-0"

A010

PRINTED: 5/19/2026 11:07:43 AM FILENAME: C:\Users\Wladia\Documents\2026015_226_ARCH_585D OFFICES_ARCH_1\Wladia\W585X.vrt



1 FIRE AND EGRESS - LEVEL 1

A013 3/32" = 1'-0"

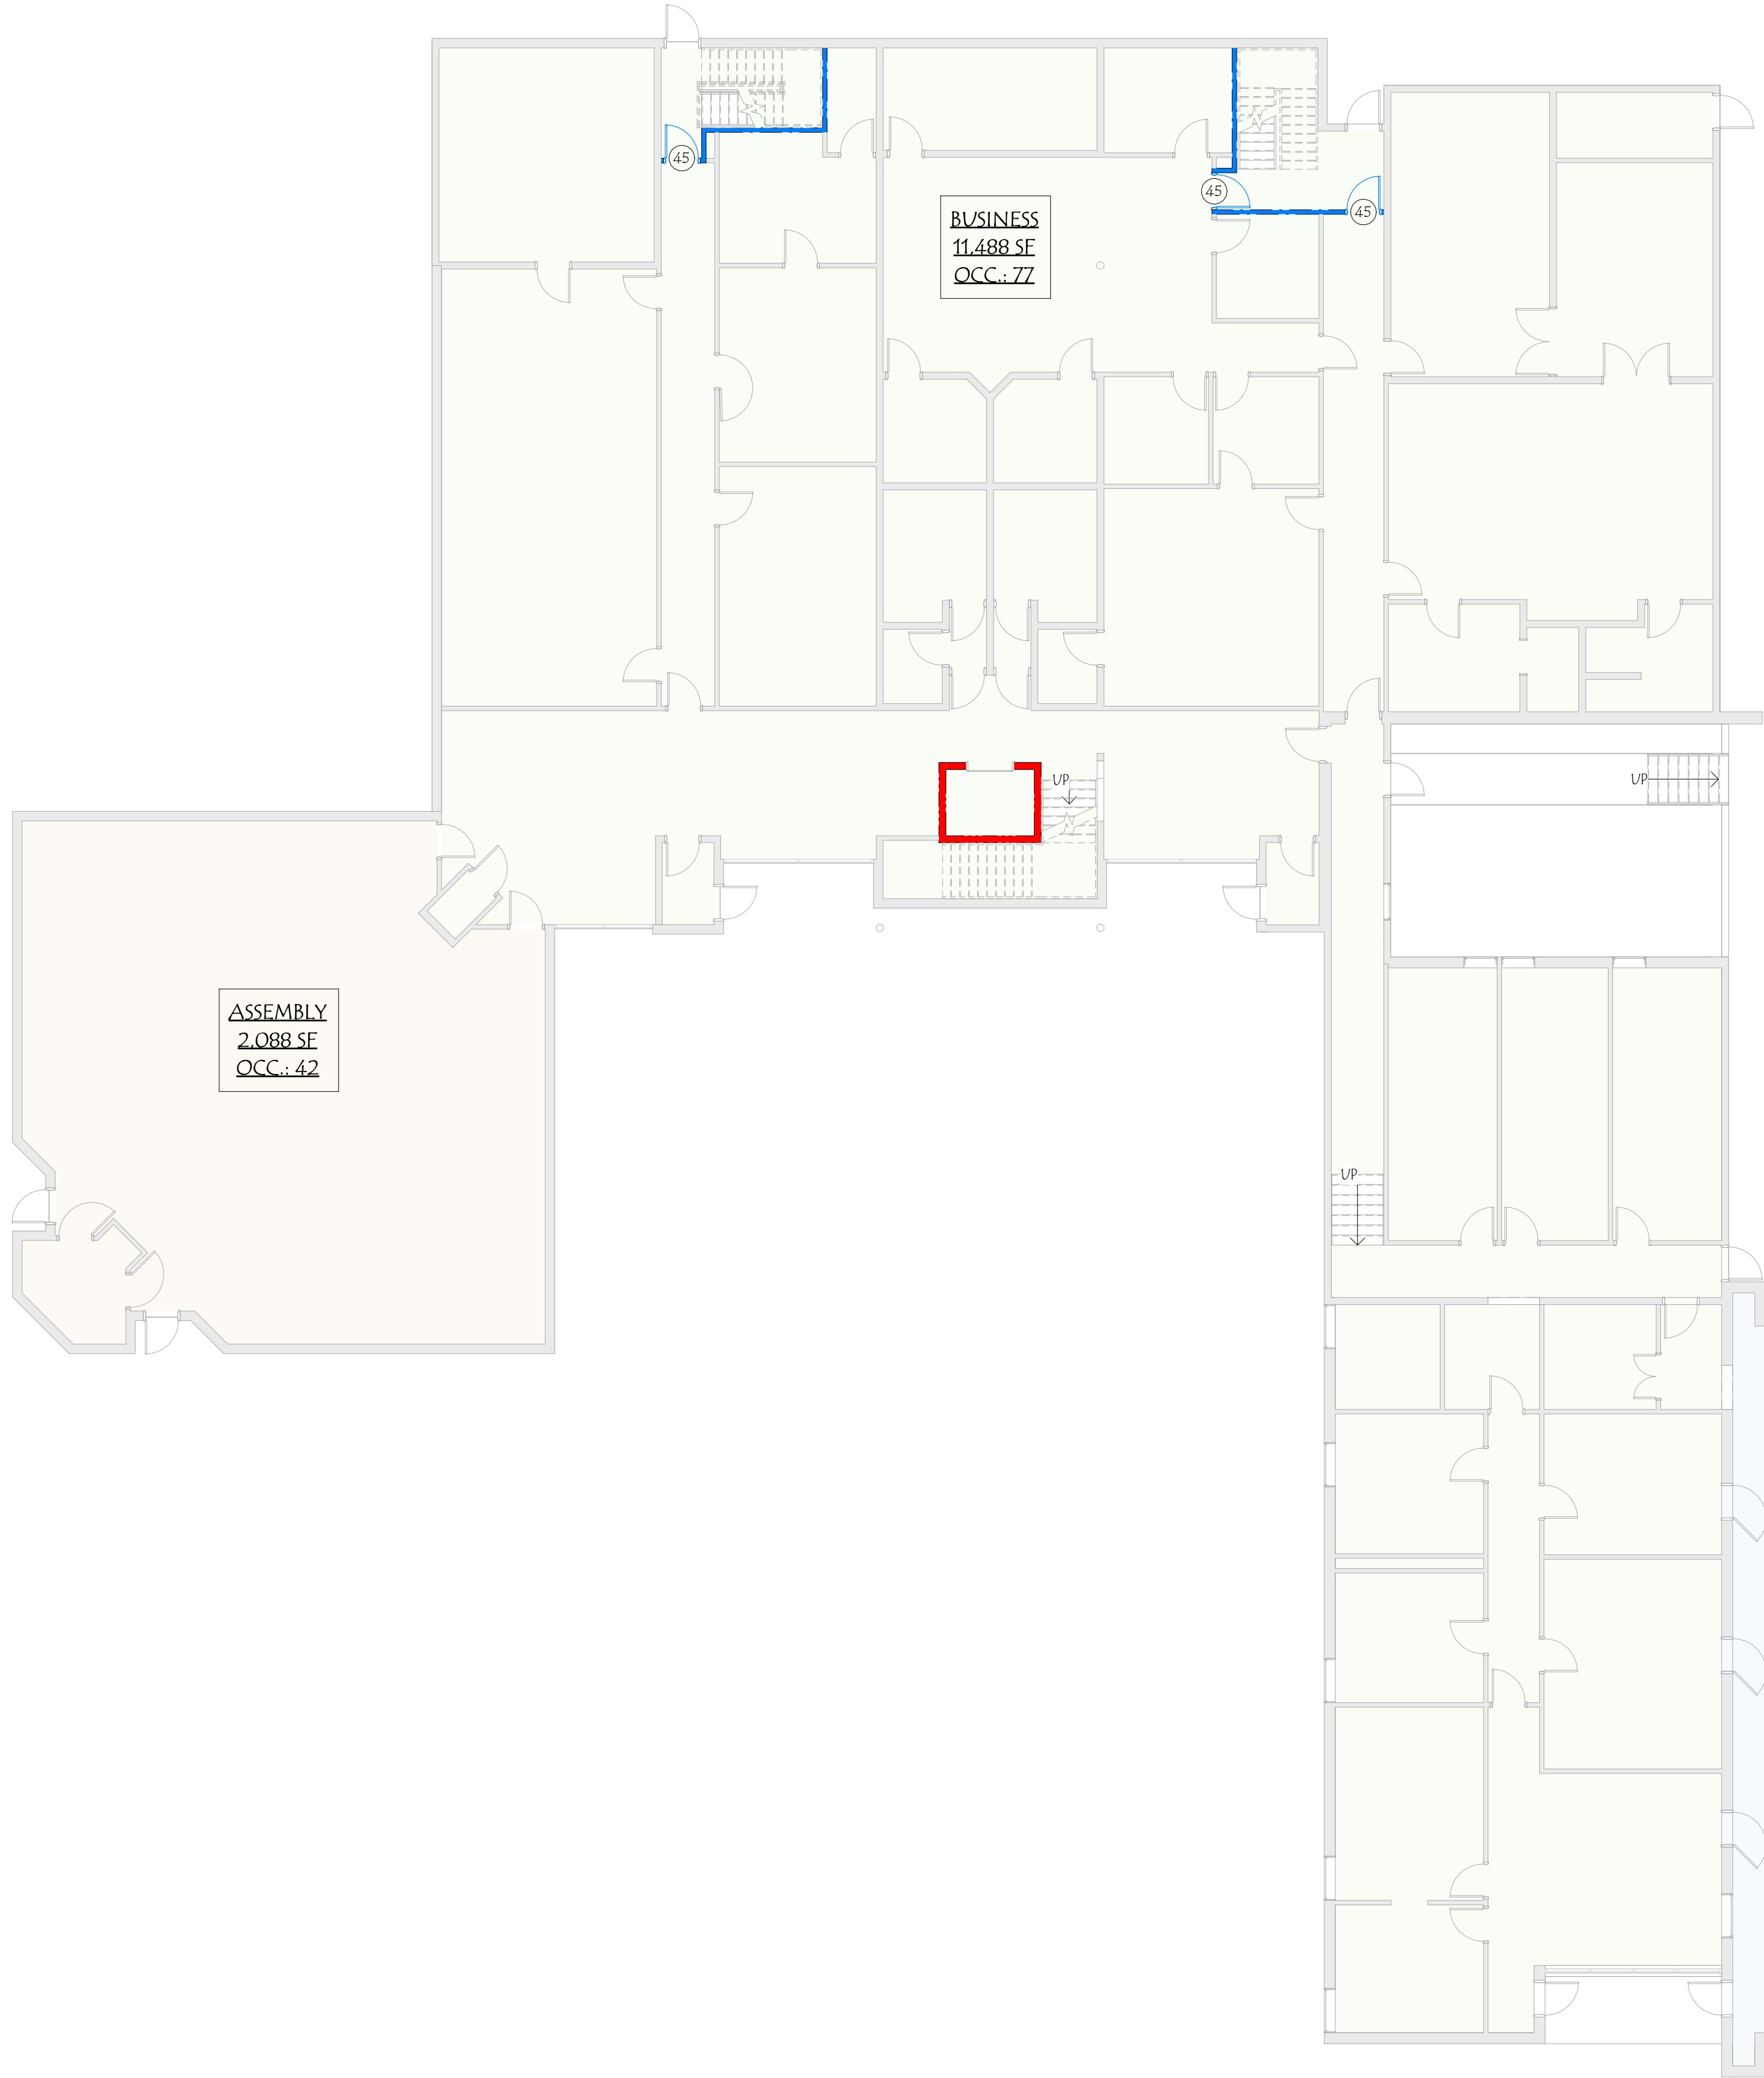

2 FIRE AND EGRESS - LEVEL 2

A013 3/32" = 1'-0"

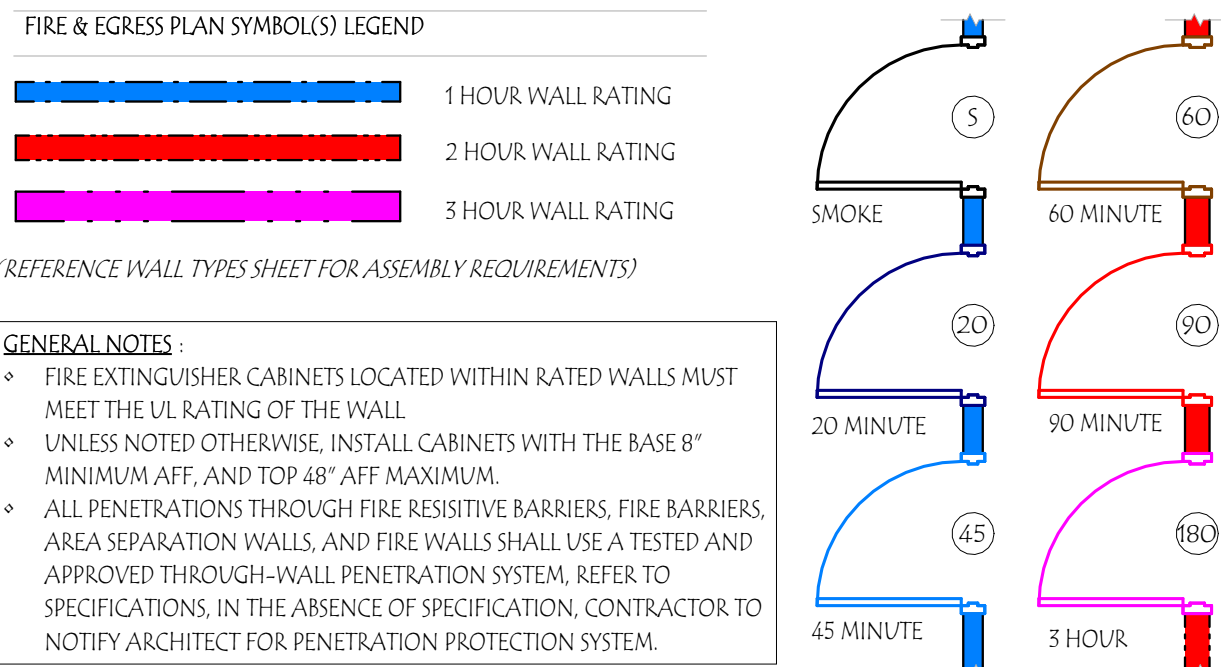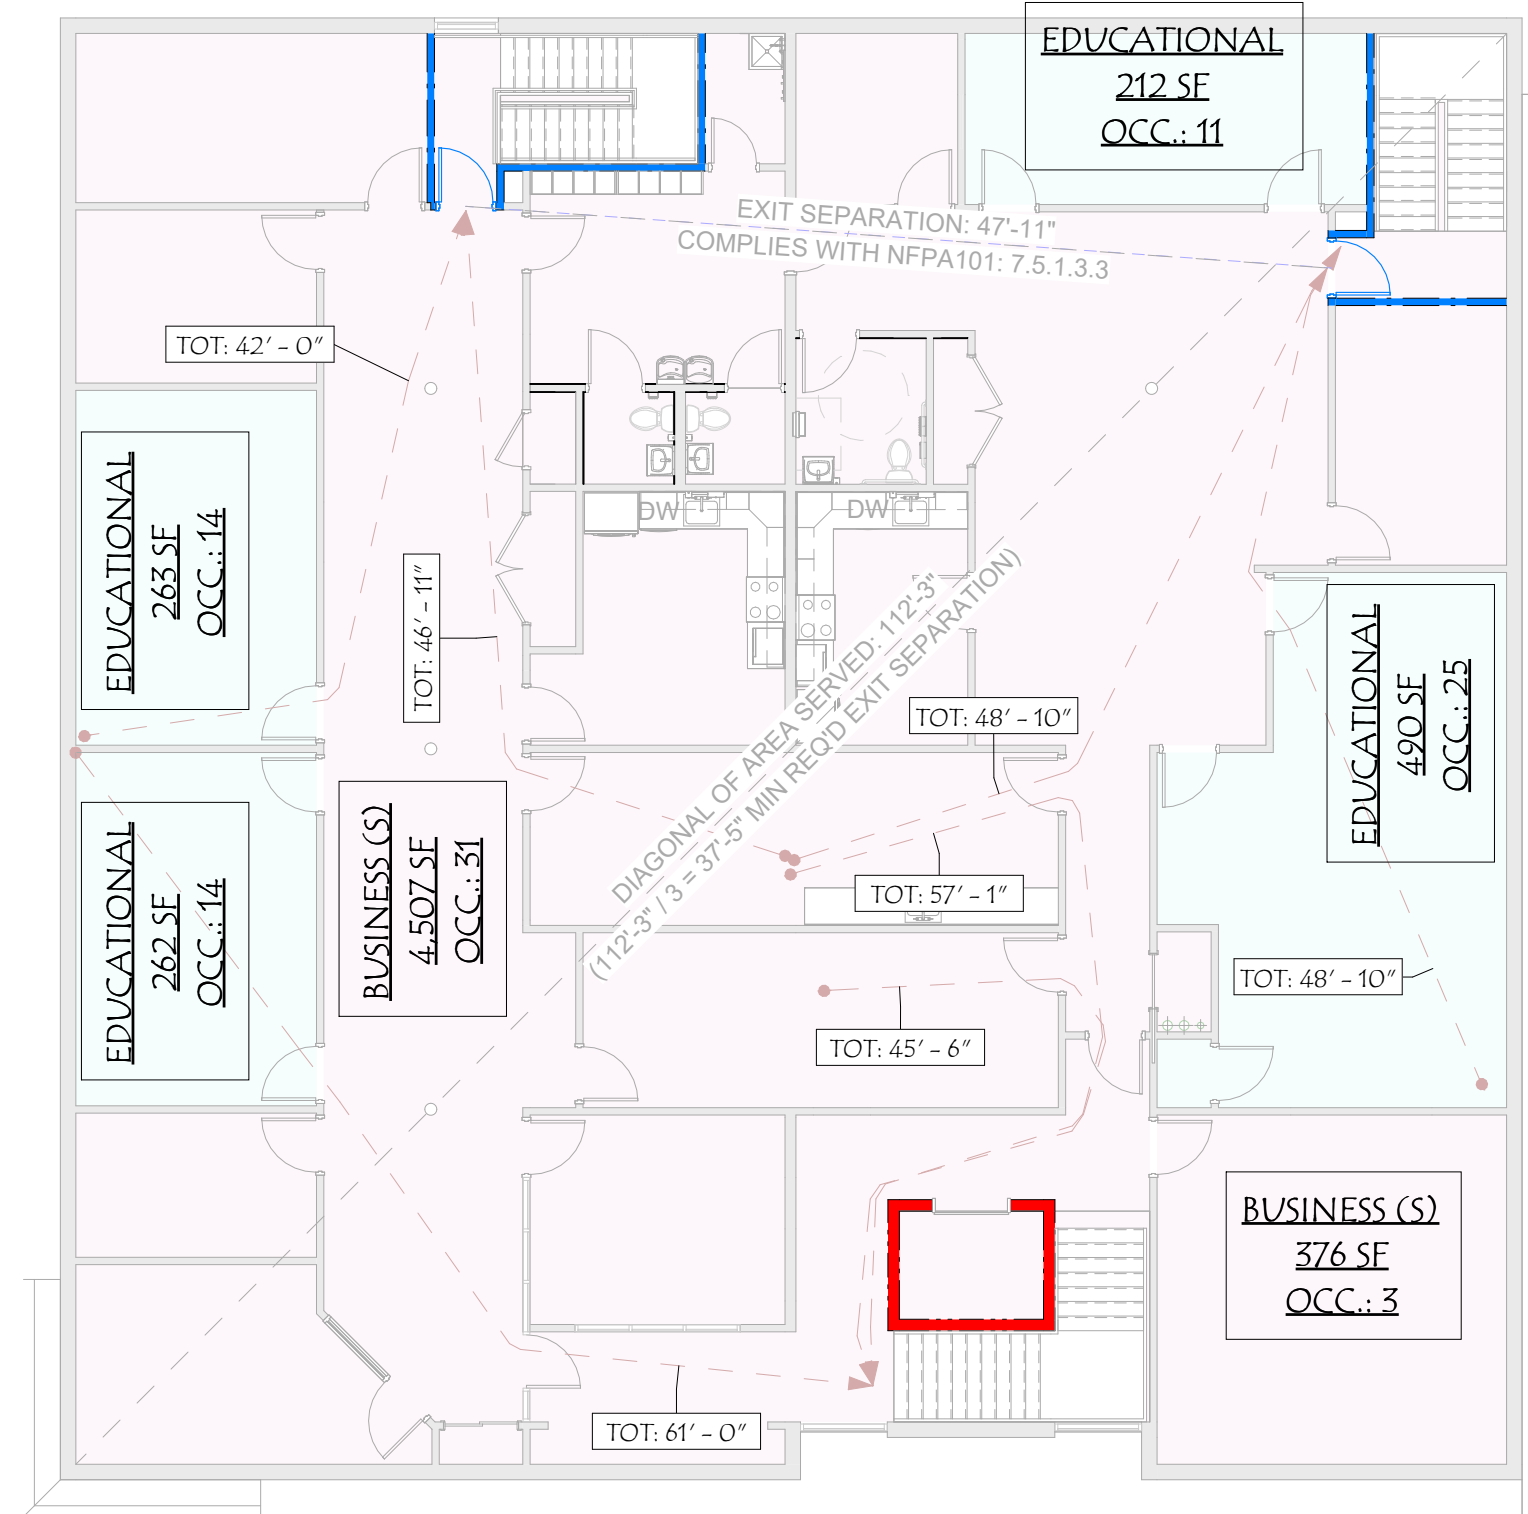

- NOTES:
- SCOPE:
 - IN ALL ACCESSIBLE CONCEALED FLOOR-CEILING, OR ATTIC SPACE, ALL FIRE WALLS, FIRE BARRIERS, FIRE PARTITIONS, AND SMOKE BARRIERS SHALL BE LABELED WITH THE ABOVE SIGNAGE.
 - A. SIGNS SHALL BE LOCATED A MAXIMUM OF 30" FROM THE END OF EACH WALL.
 - B. SIGNS SHALL BE LOCATED AT A MAXIMUM SPACING OF 30" ON CENTER.
 - SIGNAGE TO BE COMPLIANT WITH IRC-2015 SECTION 703.7
 - SIGNAGE TO BE STICKER OR PAINT STENCIL

WHERE "X" EQUALS THE WALL RATING

MIN 3/8" STROKE

"X" HOUR
FIRE/SMOKE BARRIER
PROTECT ALL OPENINGS
AND PENETRATIONS

DATE REVISION DESCRIPTION

SOUTH BURLINGTON SCHOOL DISTRICT OFFICES

SOUTH BURLINGTON, VERMONT

LIFE SAFETY FIRE AND EGRESS PLANS

PROJECT NO: 2026015

PROGRESS PRINT: 5/19/2026 11:07:43 AM

CHECKED BY: KD

DRAWN BY: KRL/CG

SCALE: As indicated

A013




38 Eastwood Drive
Suite 301
South Burlington, VT 05403
802.655.5020

wla-vt.com

OWNER
SOUTH BURLINGTON SCHOOL DISTRICT
ATTN: JEAN-MAURICE CLARK
577 DORSET STREET
SOUTH BURLINGTON, VT 05403

ARCHITECT
WIEMANN LAMPHERE ARCHITECTS
ATTN: KELLEY DESROCHES
38 EASTWOOD DRIVE, SUITE 301
SOUTH BURLINGTON, VT 05403
802.655.5020

PROJECT STATUS
NOT FOR CONSTRUCTION


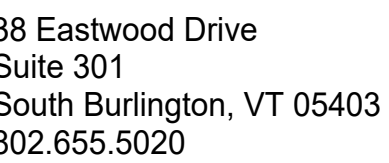


wla-vt.com

OWNER
SOUTH BURLINGTON SCHOOL DISTRICT
ATTN: JEAN-MARIE CLARK
577 DORSET STREET
SOUTH BURLINGTON, VT 05403

ARCHITECT
VIEMANN LAMPHERE ARCHITECTS
ATTN: KELLEY DESROCHES
18 EASTWOOD DRIVE, SUITE 301
SOUTH BURLINGTON, VT 05403
802-655-5020

DEMO KEY SCHEDULE	
KEY	DESCRIPTION
1A	DEMO EXISTING FLOOR FINISH, PREP CONCRETE FOR NEW FINISH
2A	DEMO EXISTING CASEWORK & PLUMBING
3A	DEMO NON CODE-COMPLIANT HANDRAILS AND GUARDRAILS
5C	REMOVE FLOOR MOUNT TOILET, PREP FOR NEW SECURITY TOILET
7A	DEMO EXG CEILING
7B	REMOVE CEILING LIGHT FIXTURE
7C	DEMO EXG AIR SUPPLY DIFFUSER
8A	DEMO EXISTING WALL
9A	SALVAGE EXISTING DOOR
9B	DEMO EXISTING DOOR
9C	DEMO BORROWED LITE

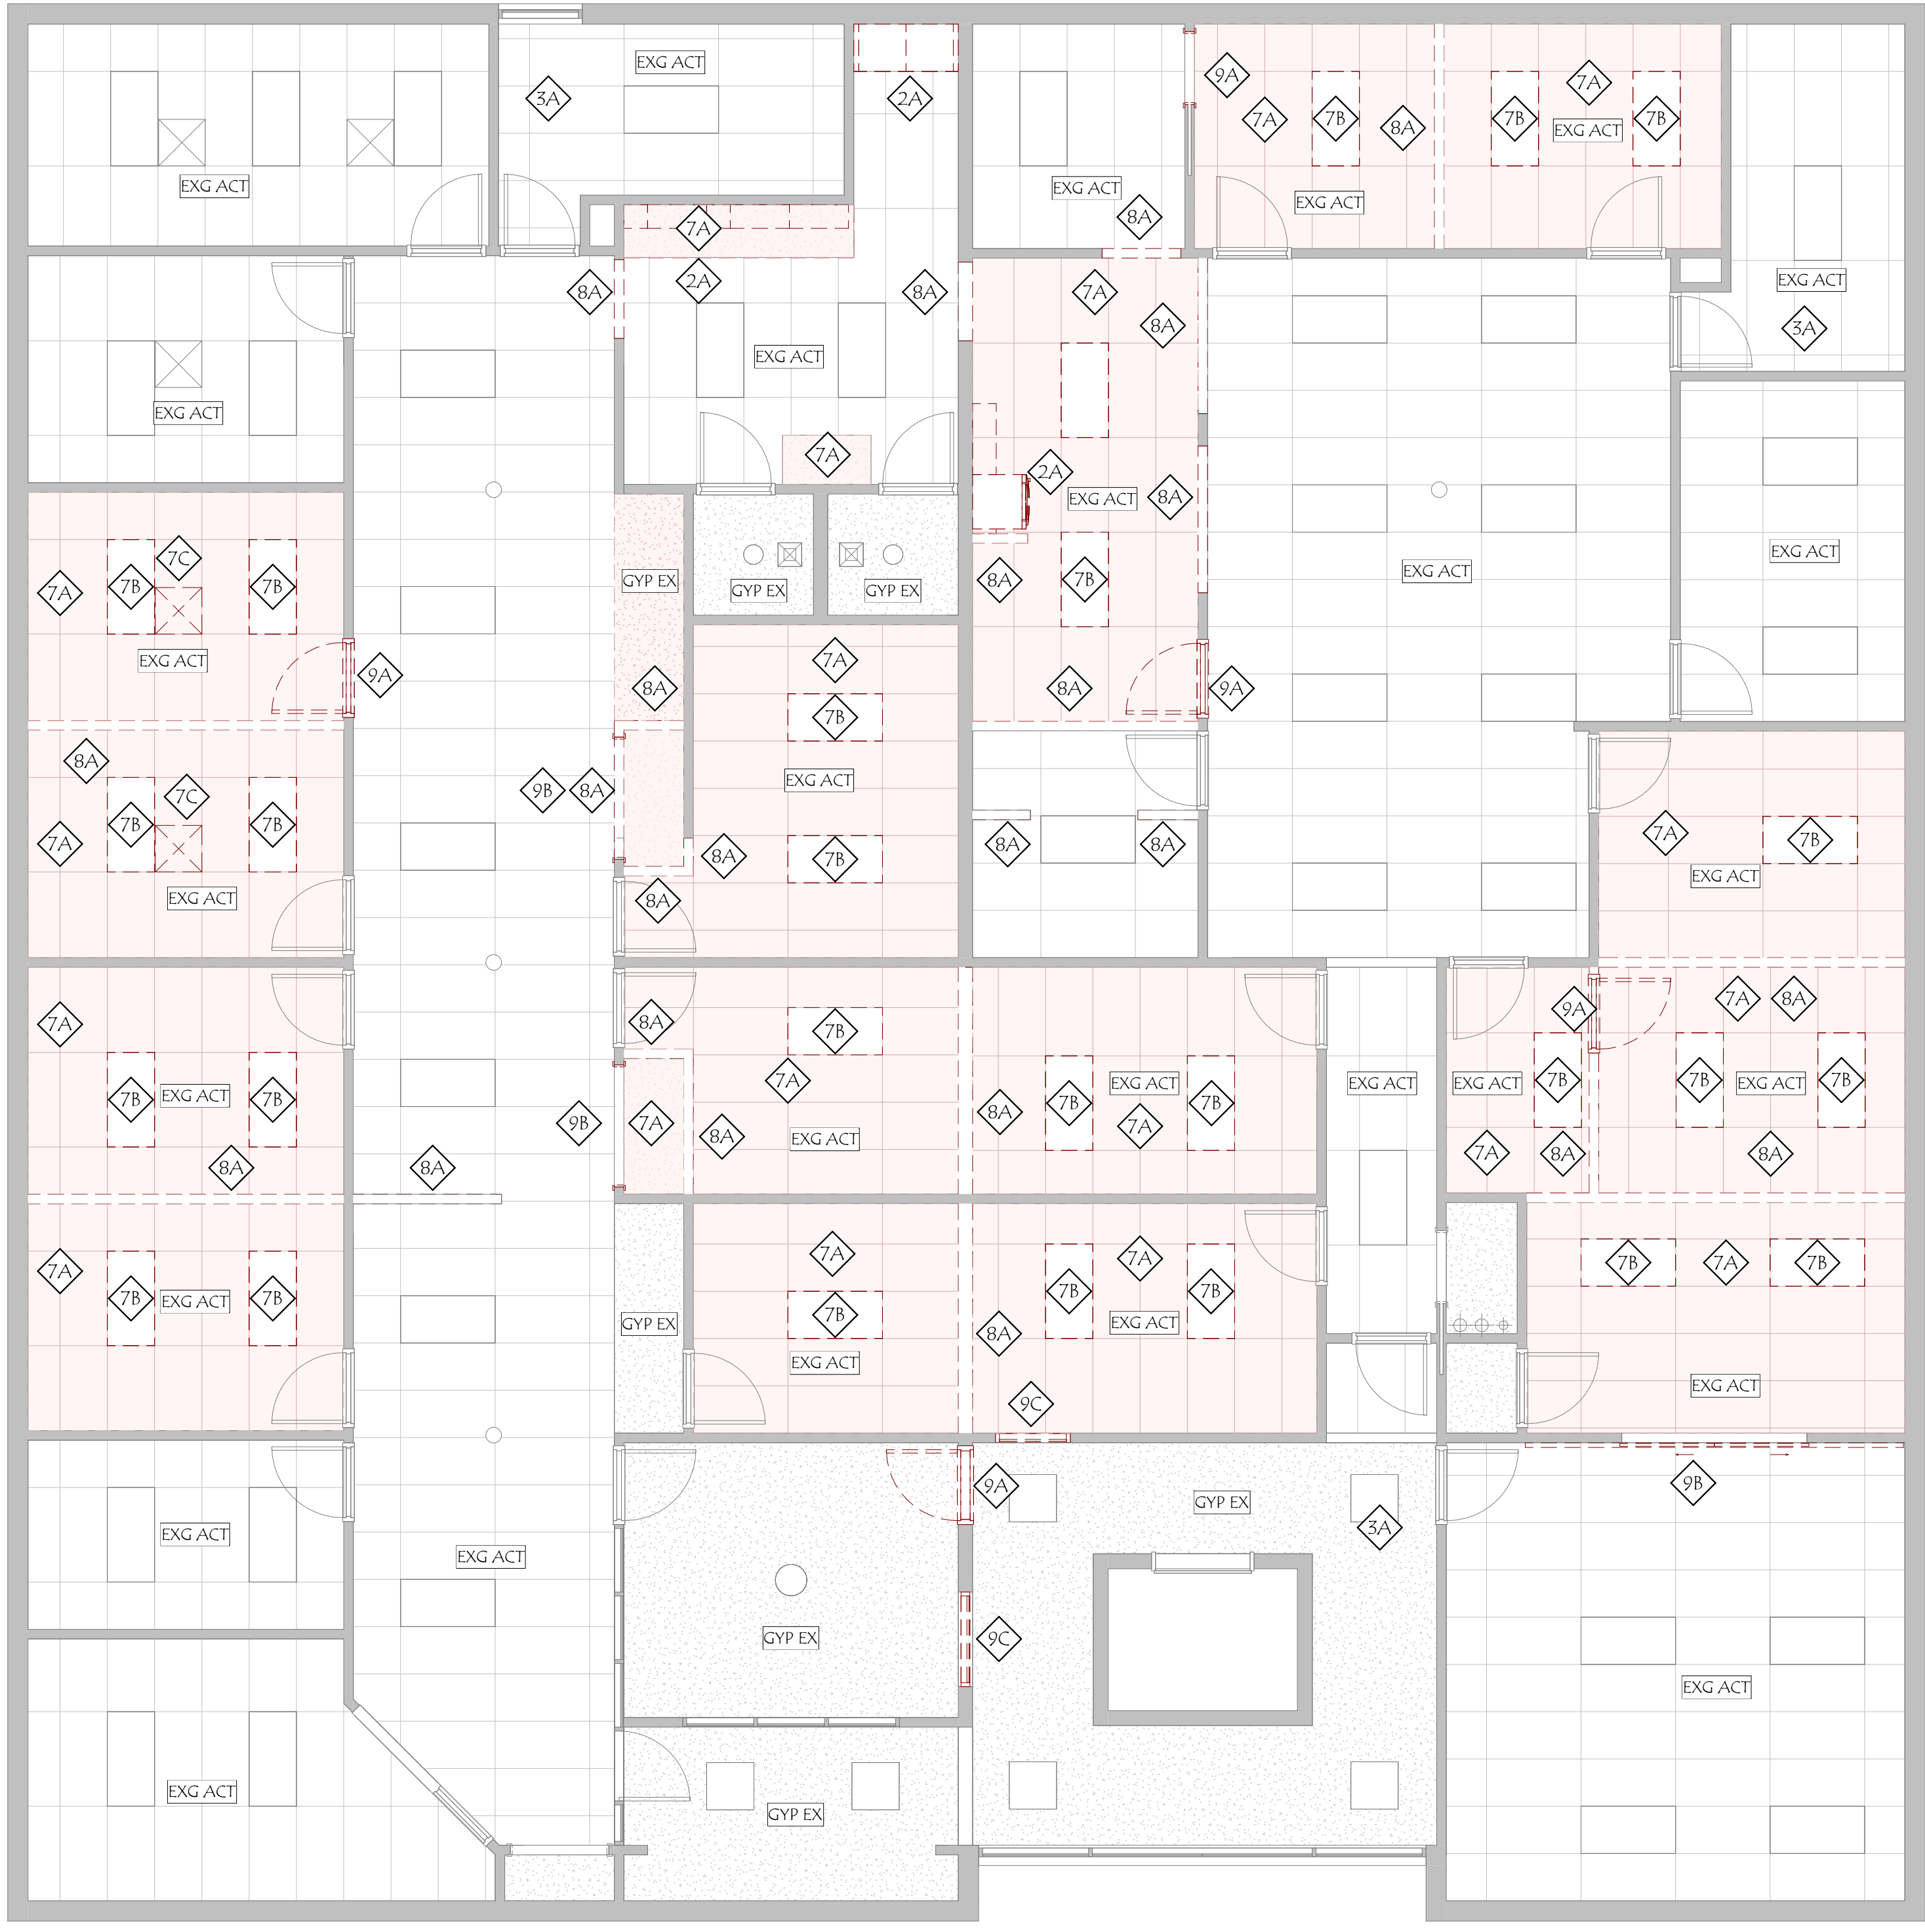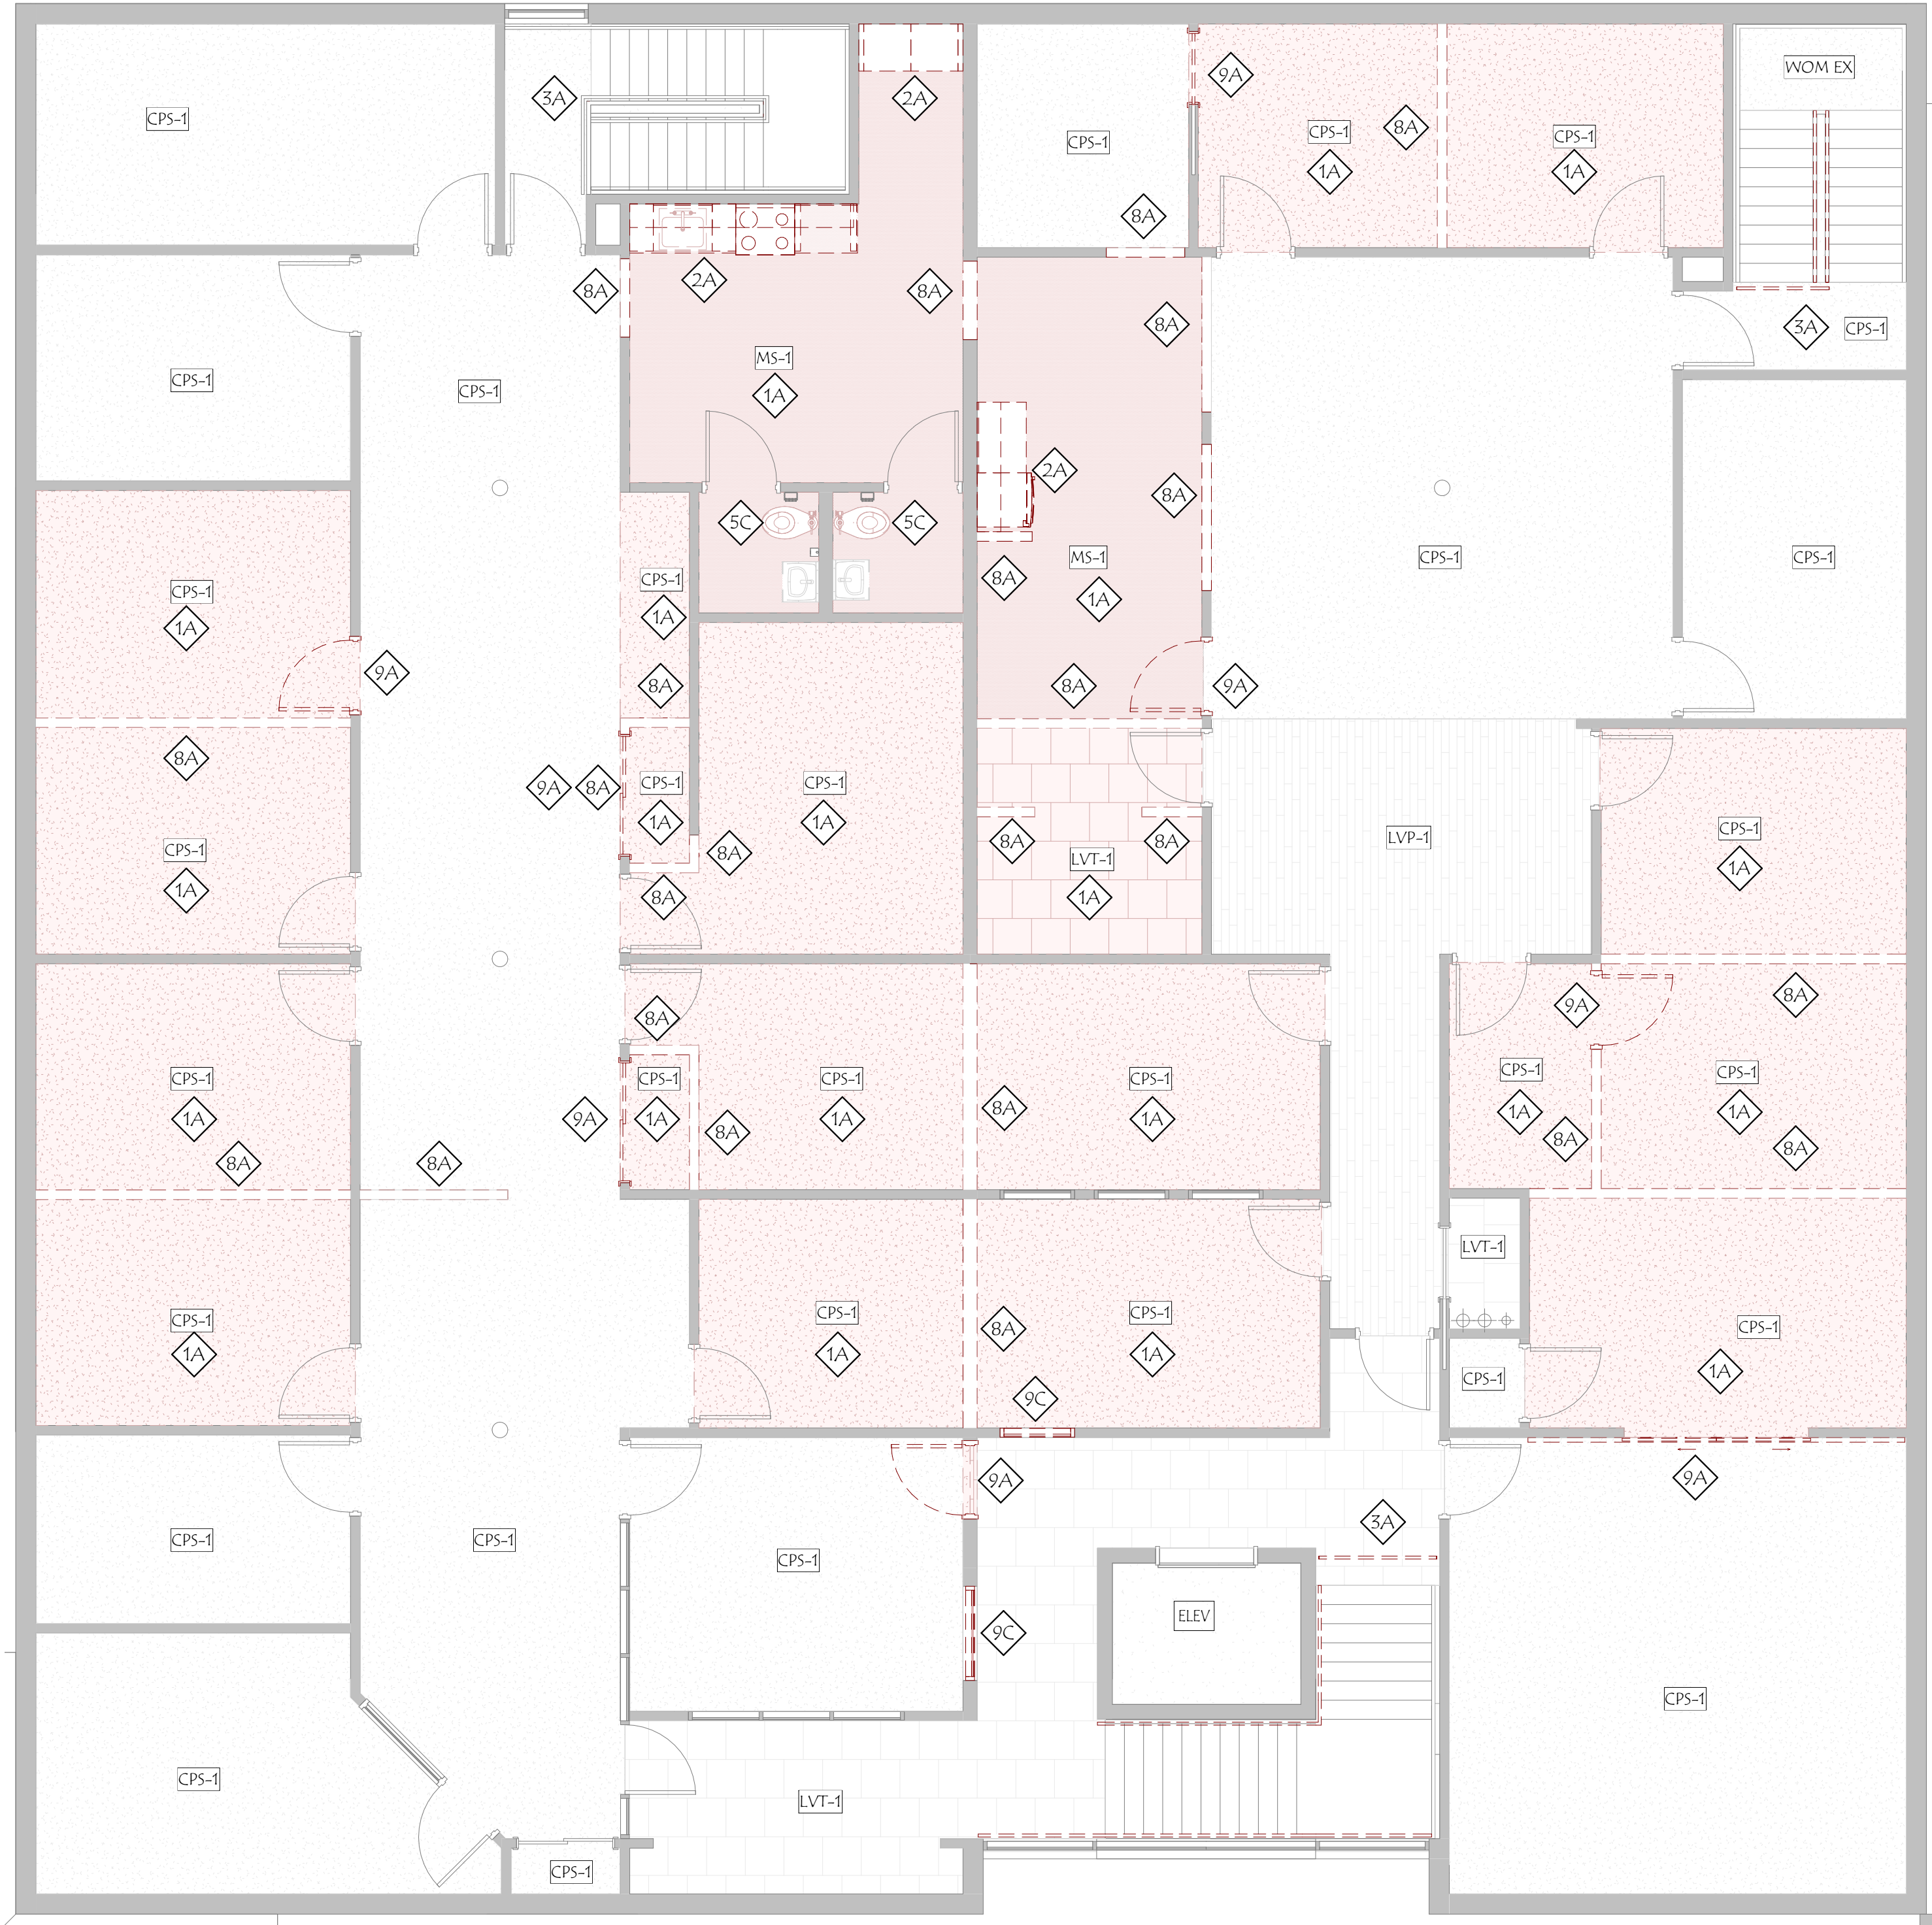

PROJECT STATUS
NOT FOR CONSTRUCTION

DATE	REVISION DESCRIPTION
------	----------------------

**SOUTH
BURLINGTON
SCHOOL
DISTRICT
OFFICES**

SOUTH BURLINGTON, VERMONT

SECOND FLOOR DEMO PLAN & DEMO RCP

PROJECT NO:	2026015
PROGRESS PRINT:	5/19/2026 11:07:45 AM
CHECKED BY:	KD
DRAWN BY:	KRL
SCALE:	3/16" = 1'-0"

D100


PRINTED: 5/19/2026 11:07:45 AM FILENAME: C:\Users\kladue\Documents\2026015_R26_ARCH_SBSD OFFICES_ARCH_kladue\NM5YX.mf

PRINTED: 5/19/2026 11:07:45 AM

2 LEVEL 2 - DEMO
D100 3/16" = 1'-0"

1 LEVEL 2 - DEMO RCP
D100 3/16" = 1'-0"

PRINTED: 5/19/2026 11:07:46 AM FILENAME: C:\Users\Nathan\Documents\2026015_226_ARCH_5850 OFFICES_ARCH_102a.dwg

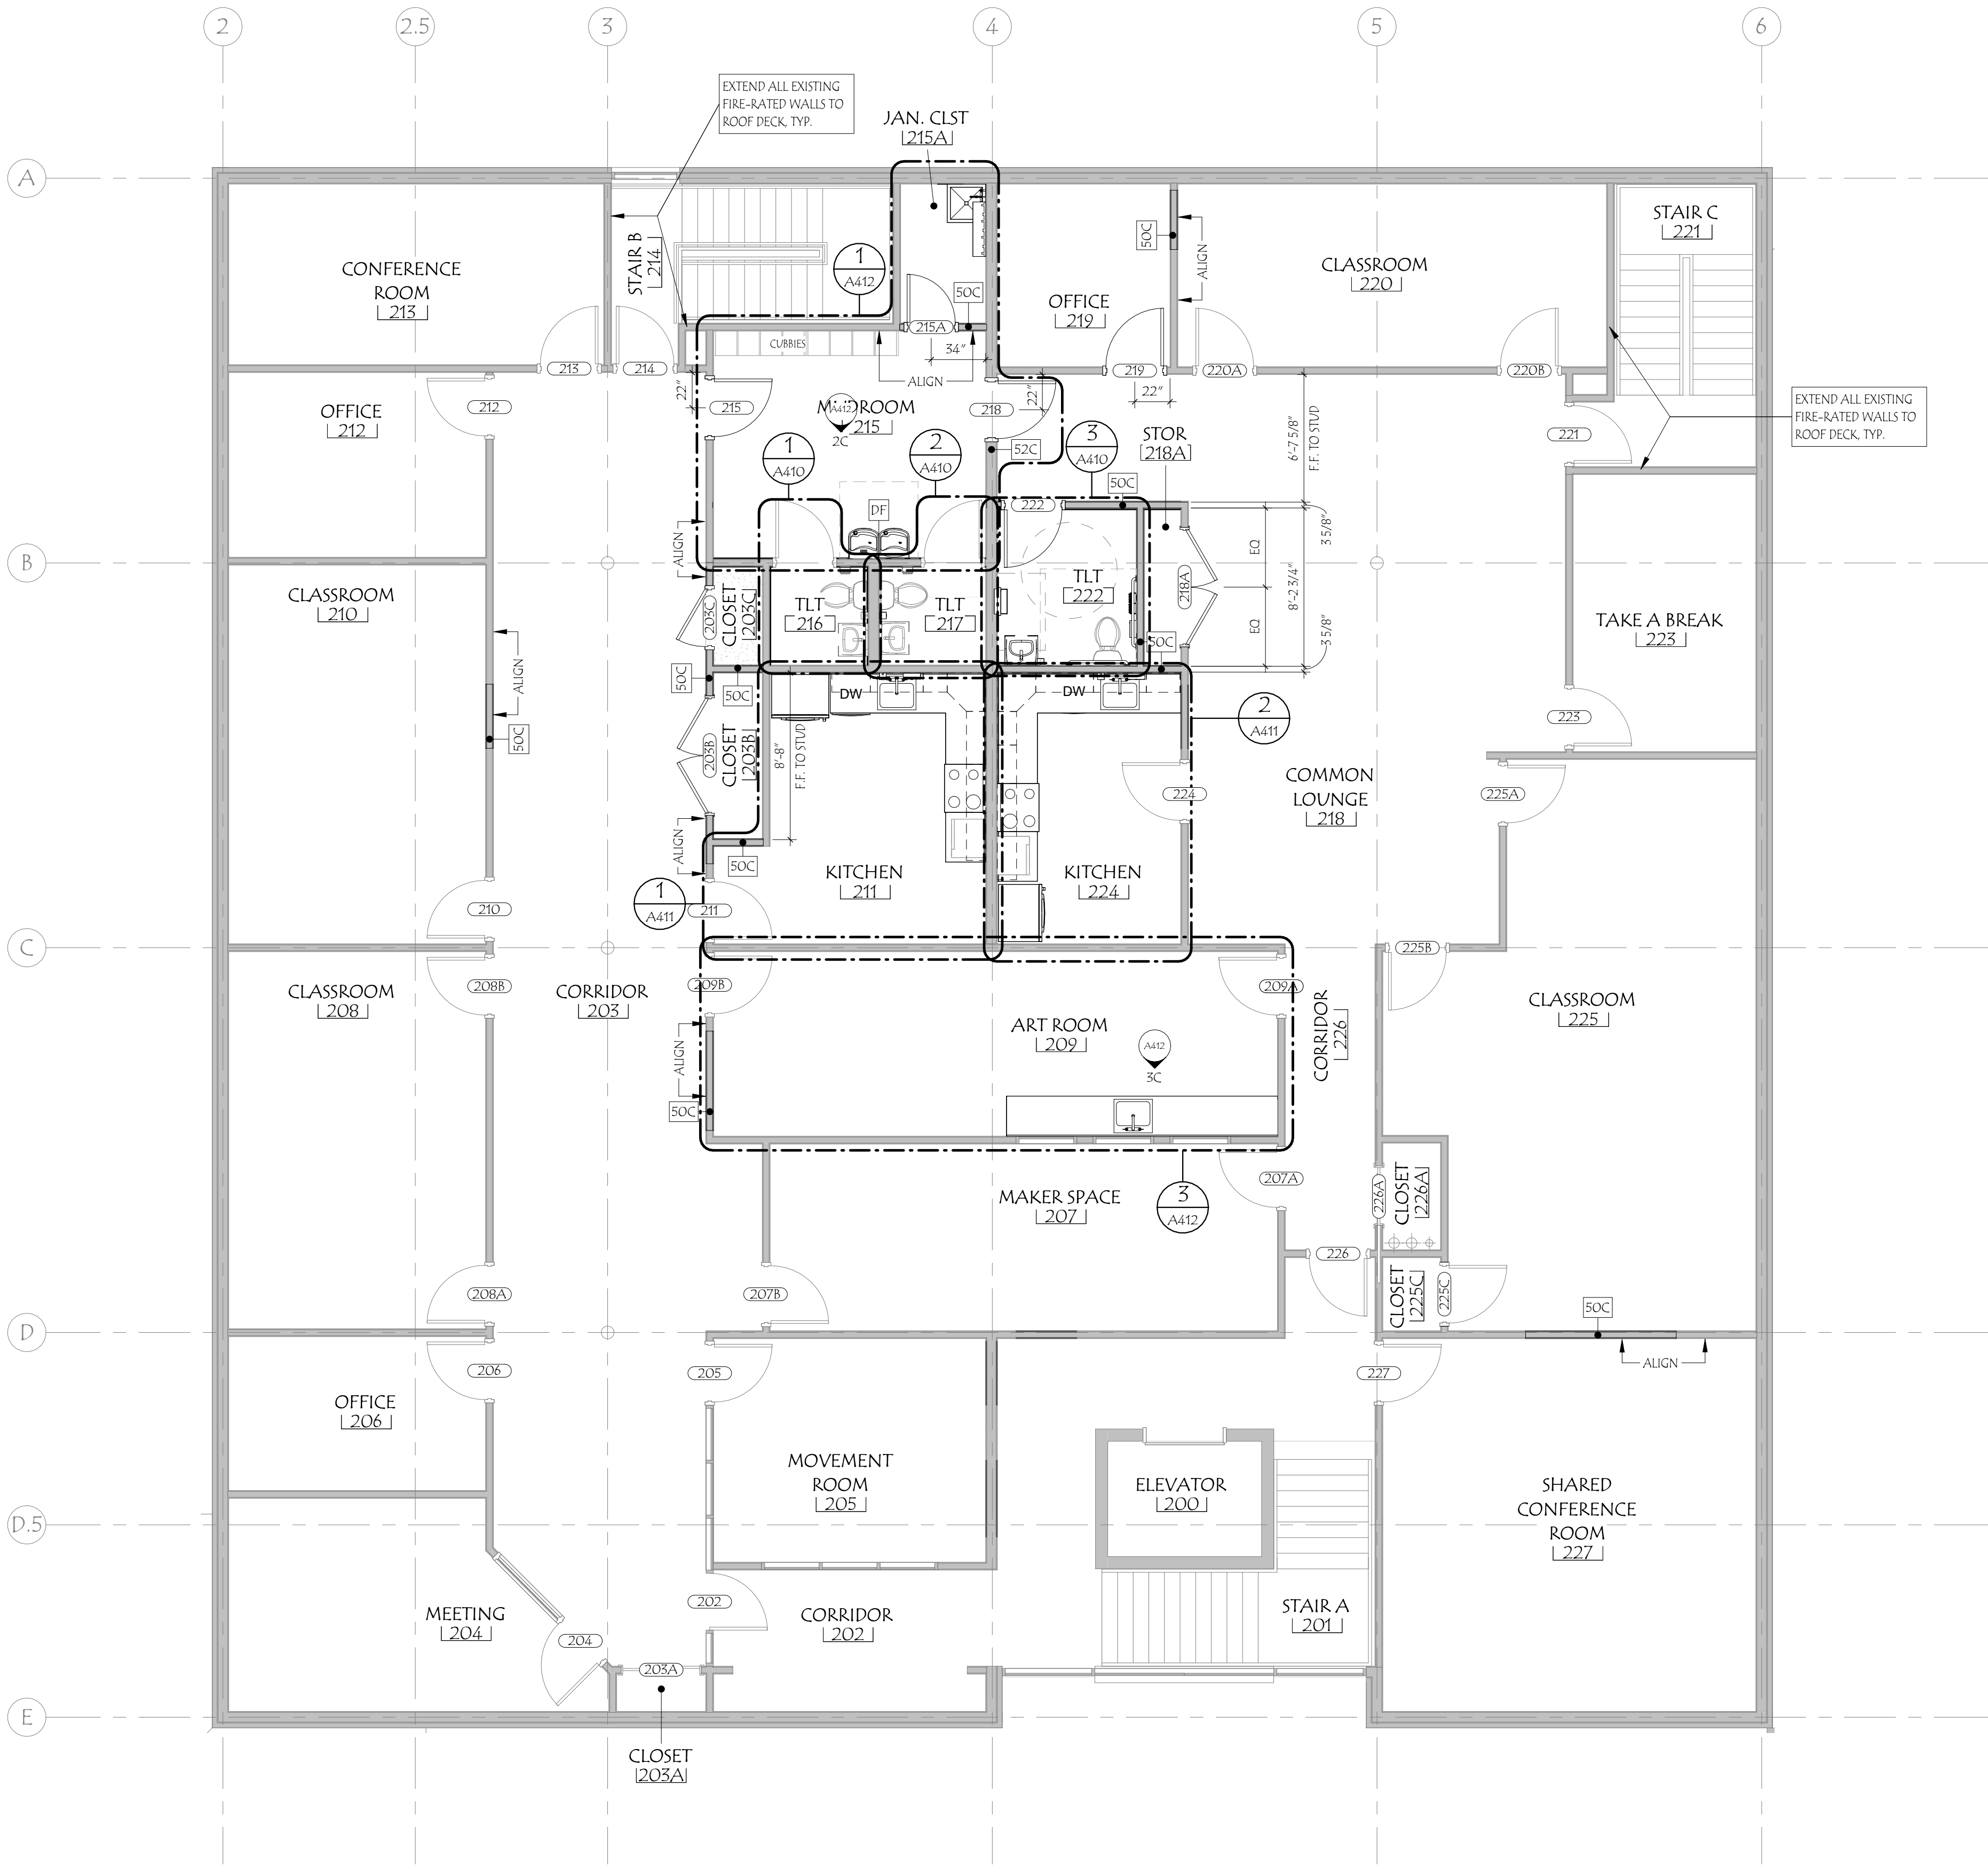

1 LEVEL 2
A101 3/16" = 1'-0"



38 Eastwood Drive
Suite 301
South Burlington, VT 05403
802.655.5020

wla-vt.com

OWNER
SOUTH BURLINGTON SCHOOL DISTRICT
ATTN: JEAN-MAURICE CLARK
577 DORSET STREET
SOUTH BURLINGTON, VT 05403

ARCHITECT
WIEMANN LAMPHERE ARCHITECTS
ATTN: KELLEY DESROCHES
38 EASTWOOD DRIVE, SUITE 301
SOUTH BURLINGTON, VT 05403
802.655.5020

PROJECT STATUS
NOT FOR CONSTRUCTION

#	DATE	REVISION DESCRIPTION
---	------	----------------------

SOUTH BURLINGTON SCHOOL DISTRICT OFFICES


 



SOUTH BURLINGTON, VERMONT




SECOND FLOOR PLAN

PROJECT NO:	2026015
PROGRESS PRINT:	5/19/2026 11:07:46 AM
CHECKED BY:	KD
DRAWN BY:	KRL/CG
SCALE:	3/16" = 1'-0"

A101

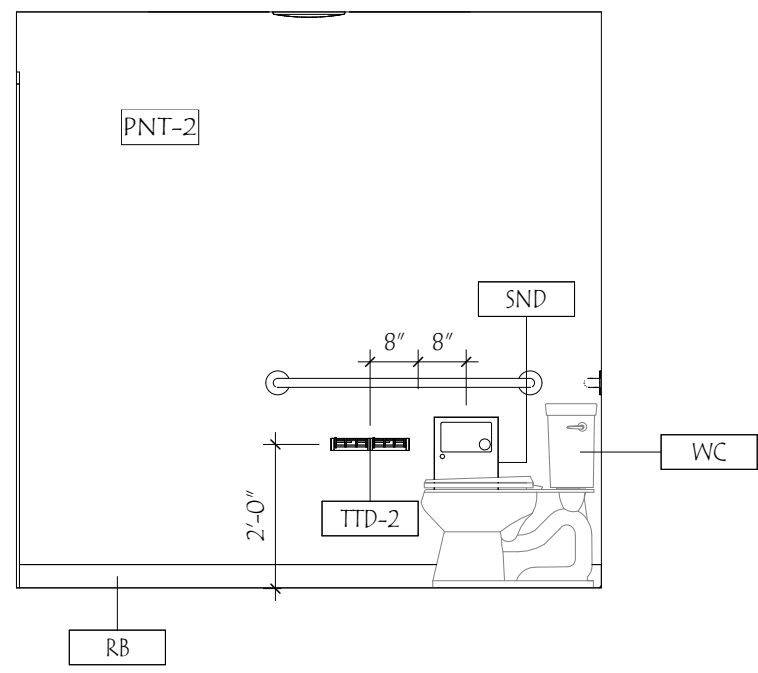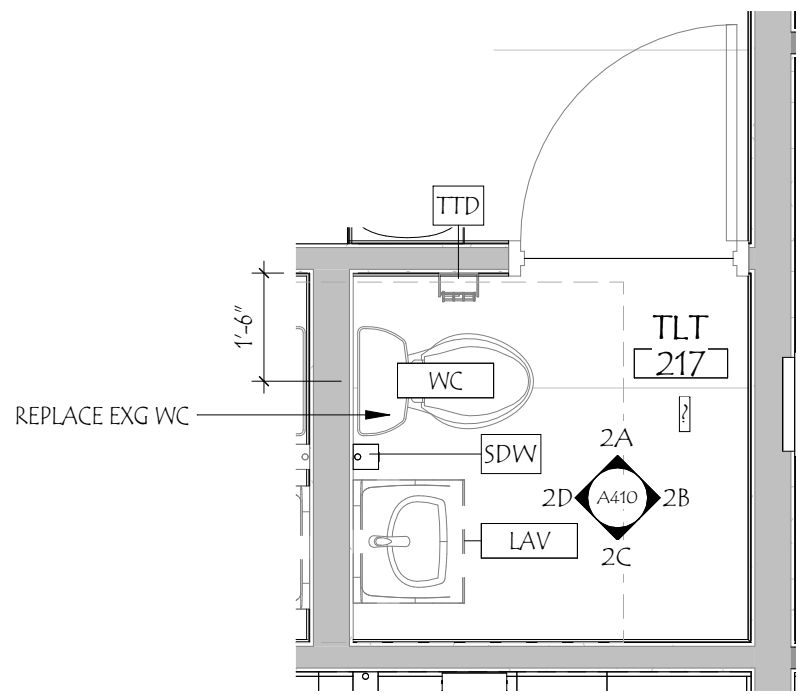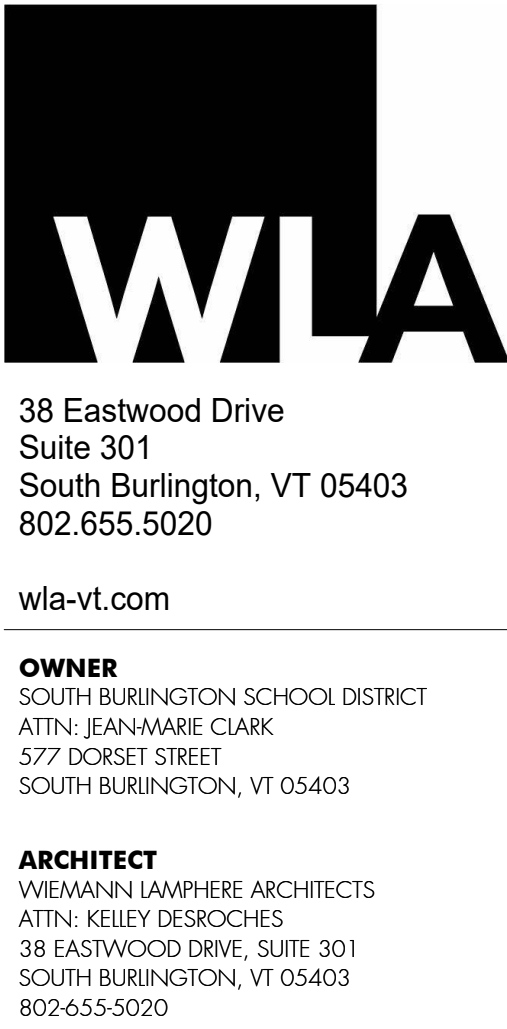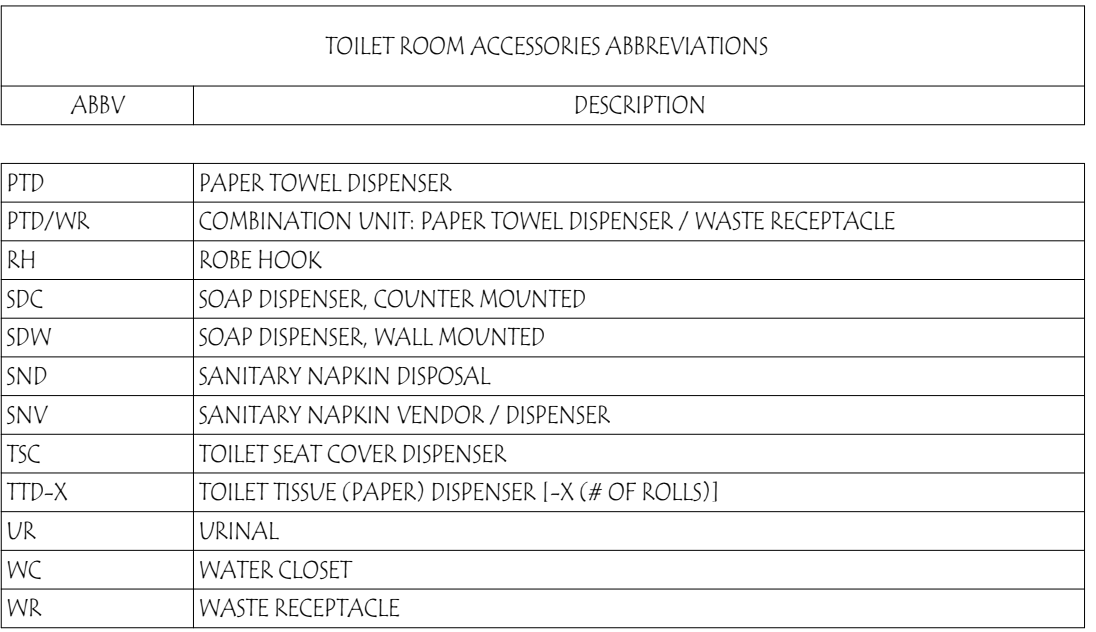

3B TLT (222) - ELEV 2
3/8" = 1'-0"

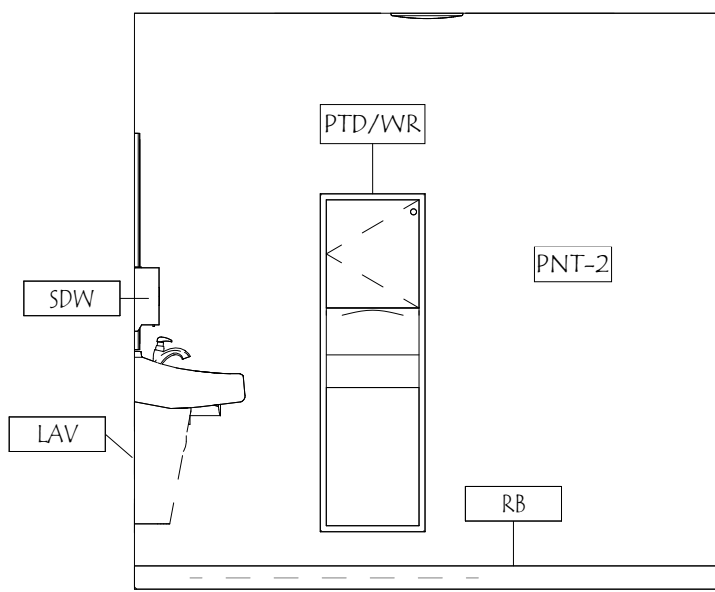

 TLT (222) - ELEV 4
3/8" = 1'-0"

PROJECT STATUS
NOT FOR CONSTRUCTION

#	DATE	REVISION DESCRIPTION
---	------	----------------------

SOUTH BURLINGTON, VERMONT

PROJECT NO: 2026015

PROJECT NO: 2026015

 
 
PROGRESS PRINT: 5/19/2026 11:07:48 AM

CHECKED BY: _____ KD


DRAWN BY: KRL/CG

SCALE: As indicated

A410




PROJECT NO:	2026015
PROGRESS PRINT:	5/19/2026 11:07:50 AM
CHECKED BY:	KD
DRAWN BY:	KRL/CG
SCALE:	3/8" = 1'-0"

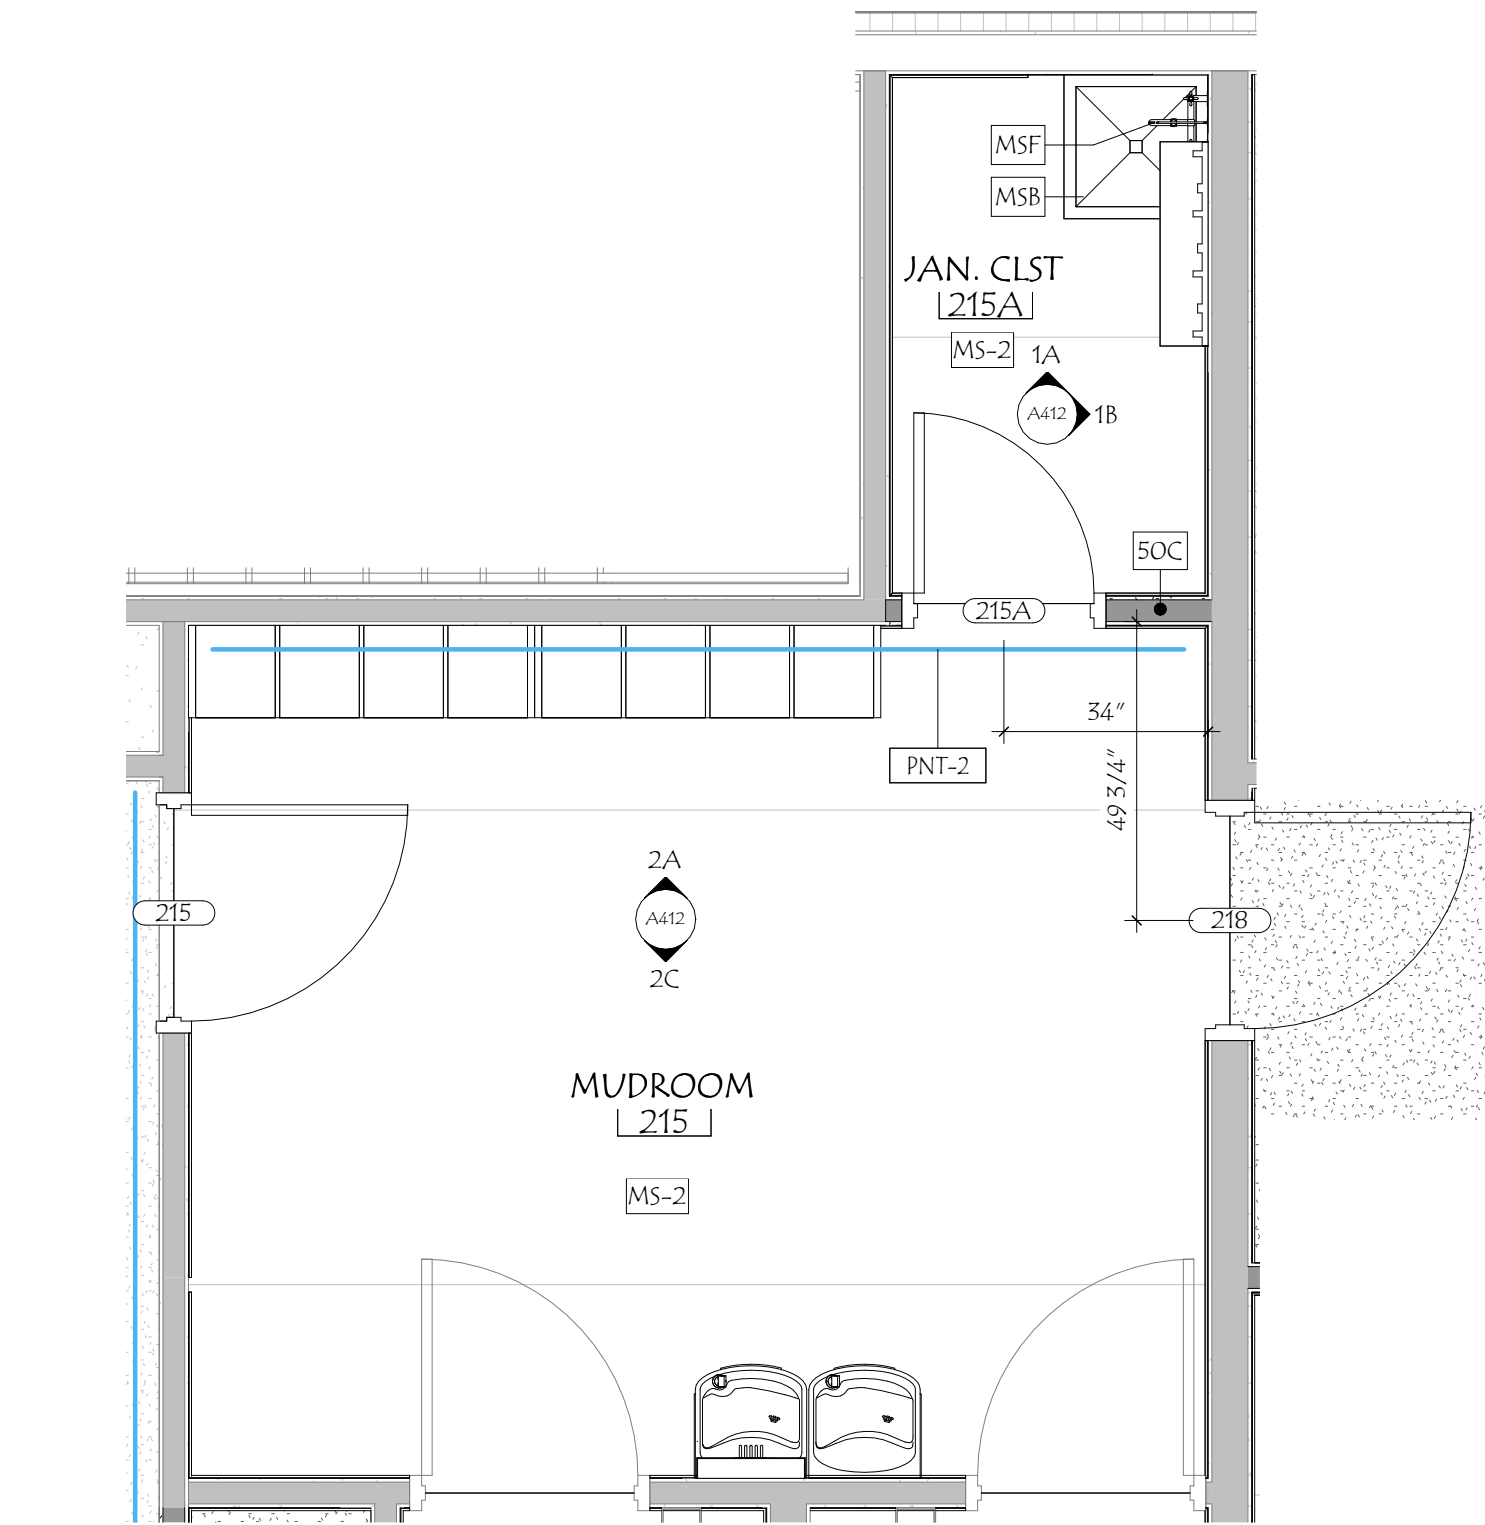


1 LEVEL 2 - MUDROOM (215) ENLARGED PLAN
A412 3/8" = 1'-0"


1A JAN. CLST (215A) - ELEV 1
3/8" = 1'-0"

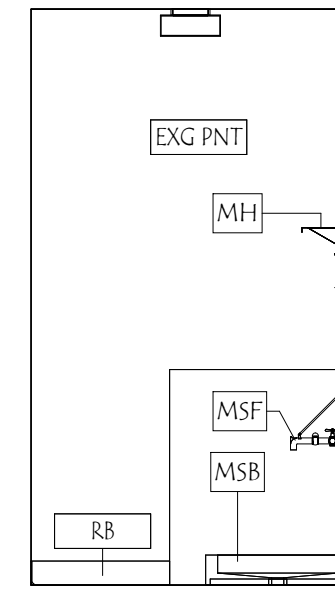



1B JAN. CLST (215A) - ELEV 2
3/8" = 1'-0"

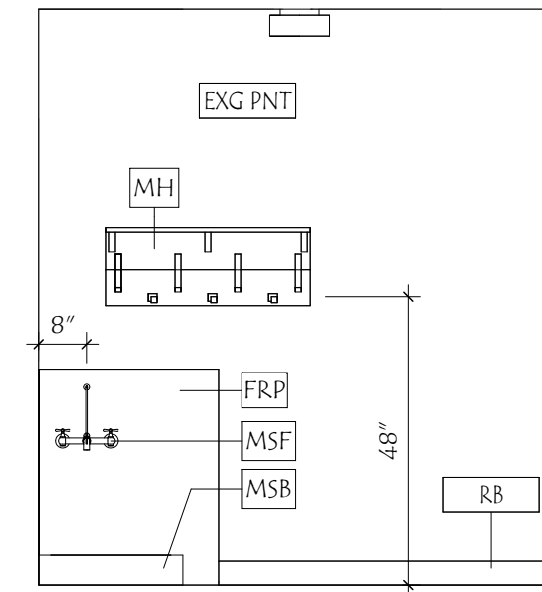


2A MUDROOM (215) - ELEV 1
3/8" = 1'-0"

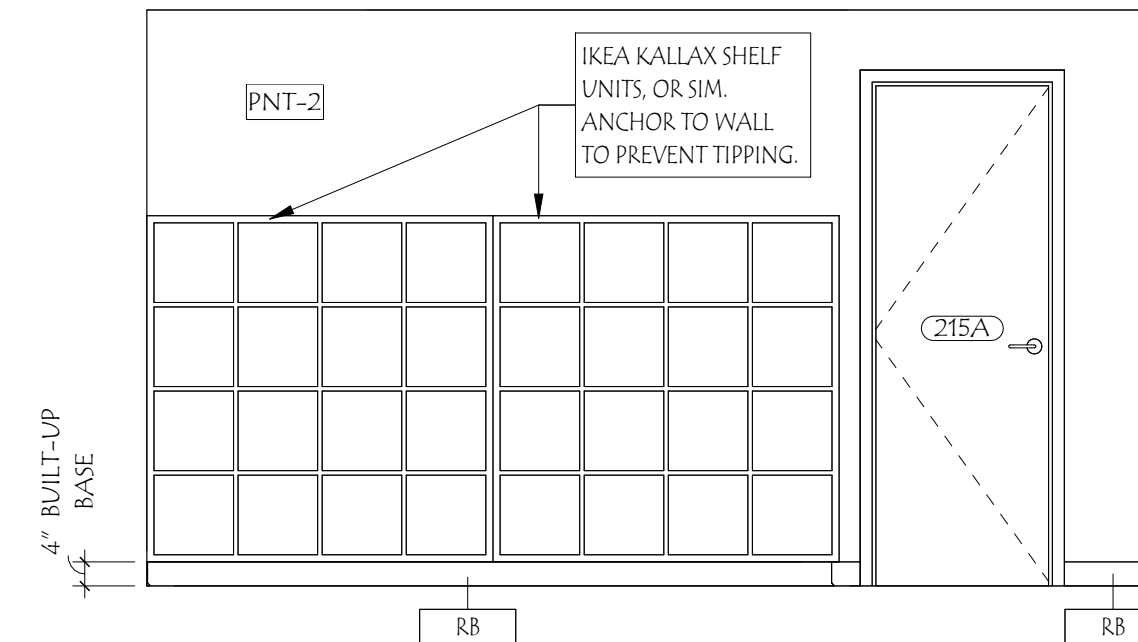

2C MUDROOM (215) - ELEV 3
3/8" = 1'-0"

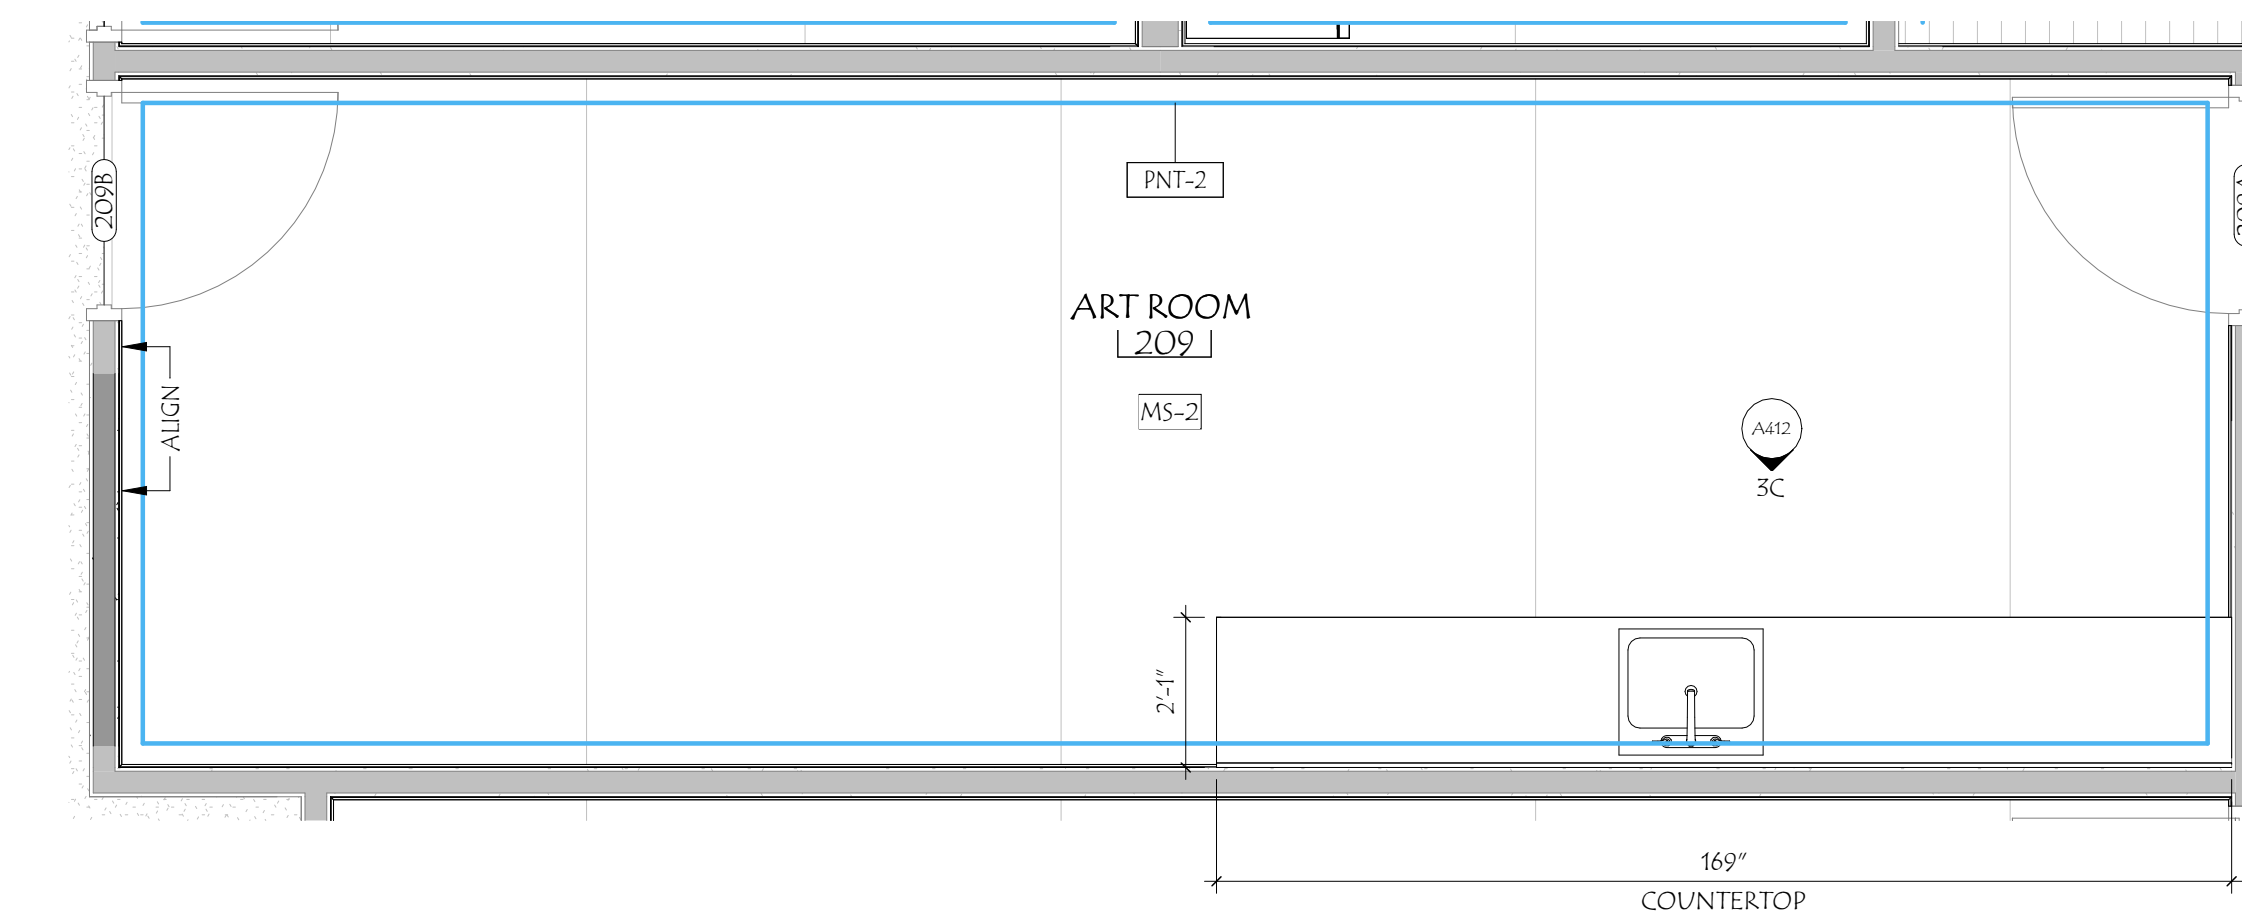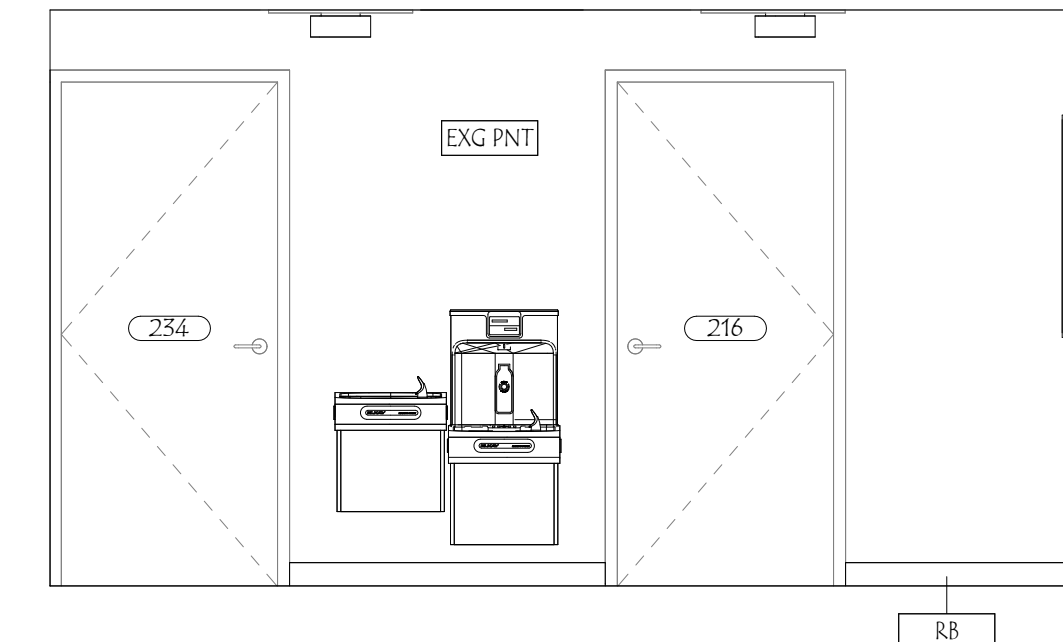

3 LEVEL 2 - ART ROOM (209) ENLARGED PLAN
A412 3/8" = 1'-0"

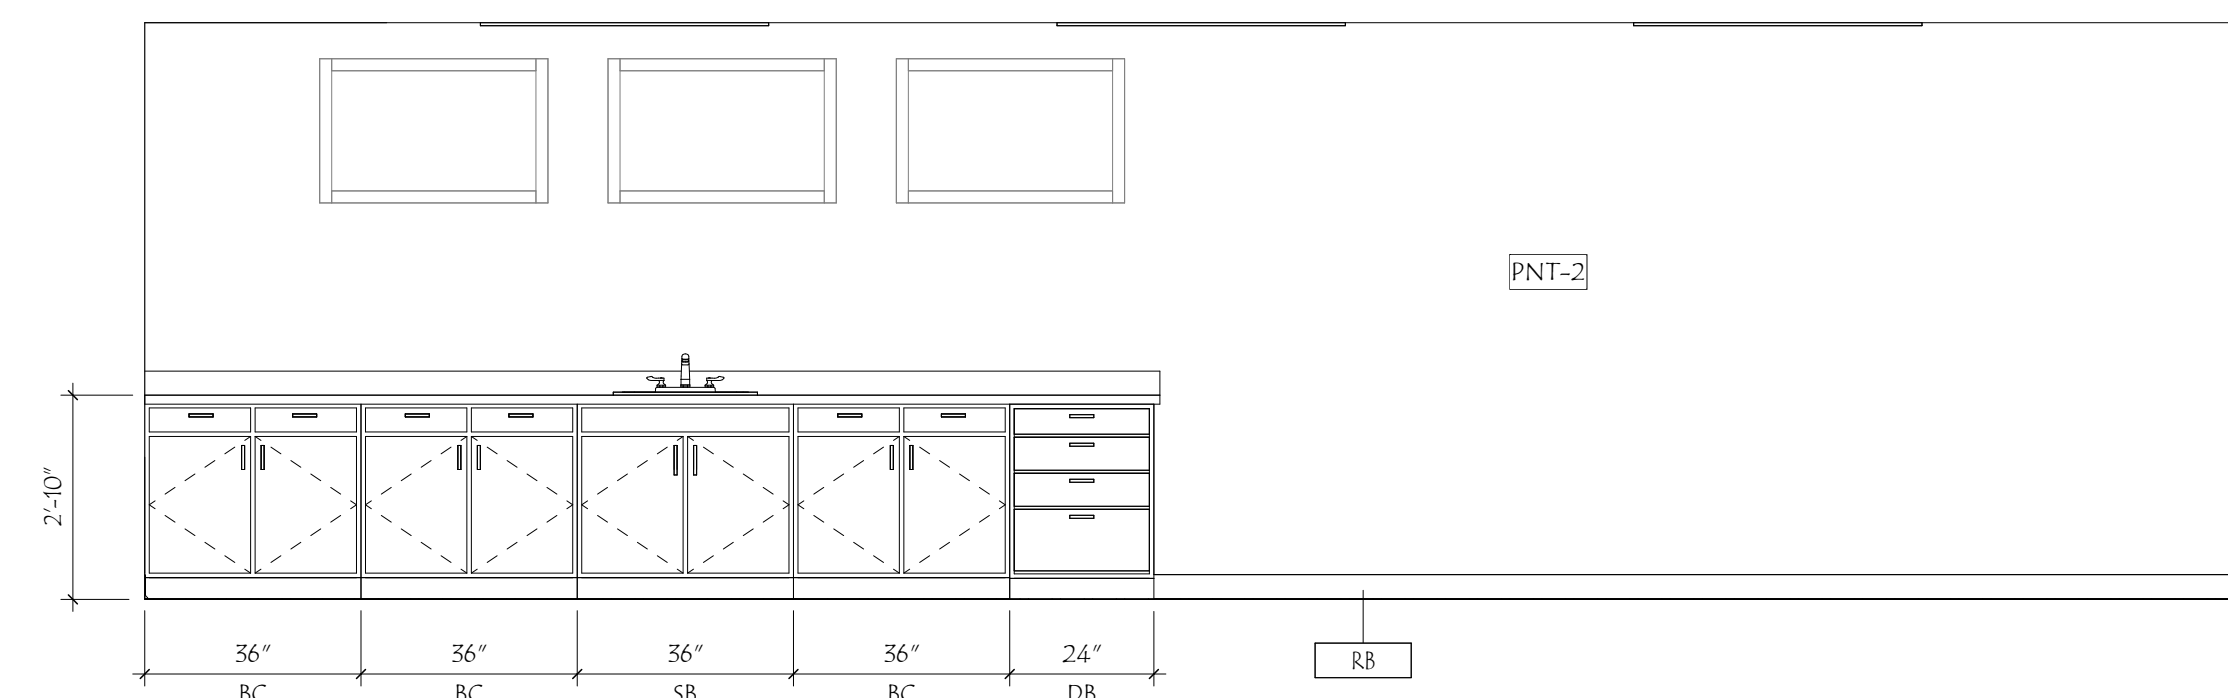

3C ART ROOM (209) - ELEV 3
3/8" = 1'-0"

PROJECT STATUS
NOT FOR CONSTRUCTION

#	DATE	REVISION DESCRIPTION
---	------	----------------------

SOUTH BURLINGTON SCHOOL DISTRICT OFFICES

SOUTH BURLINGTON, VERMONT



ENLARGED PLANS AND ELEVATIONS

PROJECT NO:	2026015
PROGRESS PRINT:	5/19/2026 11:07:50 AM
CHECKED BY:	KD
DRAWN BY:	KRL/CG
SCALE:	3/8" = 1'-0"

A412

1

DOOR TYPES

1/4" = 1'-0"

2

DOOR FRAME TYPES


1/4" = 1'-0"

10 SAFETY GLAZING
A500 1/4" = 1'-0"

OWNER
SOUTH BURLINGTON SCHOOL DISTRICT
ATTN: JEAN-MARIE CLARK
577 DORSET STREET
SOUTH BURLINGTON, VT 05403

ARCHITECT
WIEMANN LAMPHERE ARCHITECTS
ATTN: KELLEY DESROCHES
38 EASTWOOD DRIVE, SUITE 301
SOUTH BURLINGTON, VT 05403
802-655-5020

<u>ABBREVIATIONS - DOORS & WINDOWS</u>	
ACW	ALUM CLAD WOOD
ALU	ALUMINUM
ANNO	ANNOXIDIZED
CLR	CLEAR POLYURETHANE
CW	CURTAINWALL
EAC	ELECTRONIC ACCESS CONTROL
EXTG	EXISTING
F	FLUSH
F	F FRAME
FF	FACTORY FINISHED
FG	FIBERGLASS
FL	FULL LITE GLAZING
FRBG	FIRE RESISTANT RATED GLAZING
FS	FRAME SIZE/UNIT SIZE
GALV	GALVANIZED
GP	GLASS PARTITION
HM	HOLLOW METAL
HPL	HIGH PRESSURE LAMINATE
IG	INSULATED GLASS UNIT
IGH	INSULATED HOLLOW METAL
IRM	IMPACT RATED GLAZING
IS	INSULATED SAFETY GLAZING UNIT
IST	INSULATED STEEL
PNT	PAINTED
PR	PAIR
SCW	SOLID CORE W/ WOOD VENEER
SF	STOREFRONT
SG	SAFETY GLAZING (CLEAR)
TB	THERMALLY BROKEN
WD	WOOD WINDOW
WDW	WOOD WINDOW

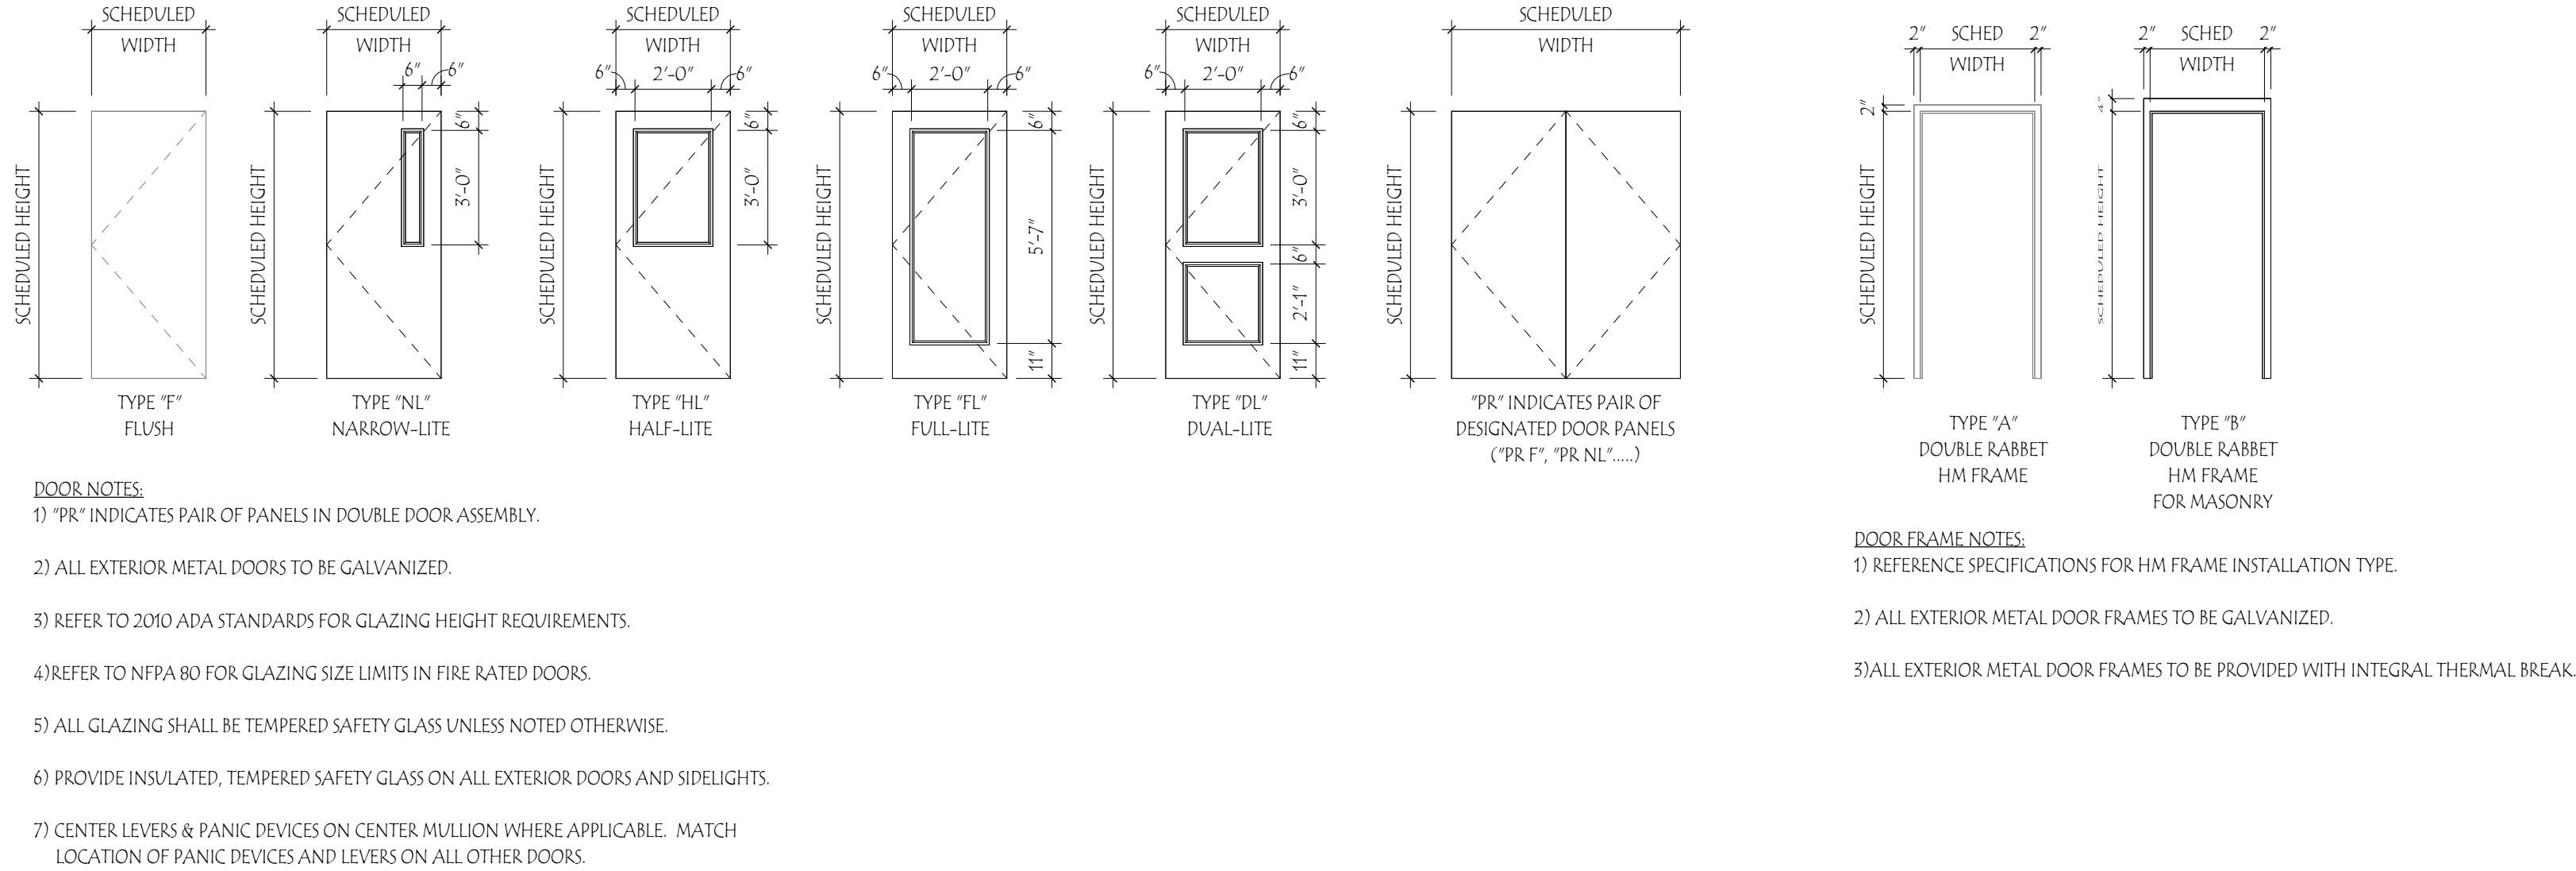

The architectural drawings illustrate the following glazing requirements:

- PLAN VIEW**: Shows a cross-section of a door or window unit. The total height is 6'-0". The top section is 2'-0" high and contains all glazing in doors. The bottom section is 4'-0" high and contains glazing within 24" of the jamb of any door up to the top of the frame.
- SAFETY GLAZING REQUIREMENT AT BOTTOM OF STAIRS**: A plan view of a stair landing area. It shows a curved wall section with a radius of 18'-0" and a width of 3'-0". The requirement states that safety glazing may include walls parallel to or opposite run of stairs.
- GLAZING ENCLOSING TUB, POOL OR SIMILAR WET AREA AND LESS THAN 60" ABOVE A STANDING SURFACE**: A side elevation showing a tub or pool enclosure. The height above the standing surface is 5'-0" or less. The glazing is shown as a hatched pattern.
- GLAZING WHICH IS PART OF ANY GUARD OR RAIL**: A side elevation showing a guard or rail system. The height above the walking surface is 5'-0" or more. The glazing is shown as a hatched pattern.
- GLAZING WITHIN 3'-0" OF WALKING SURFACES MEETING BOTH DIMENSIONS ABOVE, AND WITH TOTAL AREA ABOVE 9 SQUARE FEET**: A side elevation showing a glazing panel. The height above the walking surface is 5'-0" or more. The width is 3'-0" or more. The total area is greater than 9 square feet. The glazing is shown as a hatched pattern.
- GLAZING WITHIN 36 INCHES HORIZONTALLY OF ANY STAIR OR WITHIN 60 INCHES HORIZONTALLY OF THE BOTTOM TREAD OF A STAIRWAY AND LESS THAN 60 INCHES ABOVE THE NOSE OF THE TREAD**: A side elevation showing a stairway. The horizontal distance from the nose of the tread to the glazing is 36 inches or less. The vertical distance from the nose of the tread to the glazing is 60 inches or less. The glazing is shown as a hatched pattern.

#	DATE	REVISION DESCRIPTION
SOUTH BURLINGTON SCHOOL DISTRICT OFFICES		

SOUTH BURLINGTON, VERMONT 

DOOR SCHEDULE

A500


PRINTED: 5/19/2026 11:07:53 AM FILENAME: C:\Users\Nikola\Documents\2026015_226_ARCH_5850 OFFICES_ARCH_1\02a\A600.vrx

ROOM FINISH SCHEDULE																			
ROOM		FLOORS			WALLS												CEILING		REMARKS / NOTES
#	NAME	COORDINATE EXTENTS WITH PLAN			WEST		SOUTH		EAST		NORTH		SUBSTRATE	FINISH					
		SUBSTRATE	FINISH	WALL BASE	SUBSTRATE	FINISH	SUBSTRATE	FINISH	SUBSTRATE	FINISH	SUBSTRATE	FINISH							
200	ELEVATOR	-	EXISTING	EXISTING	-	EXISTING	-	EXISTING	-	EXISTING	-	EXISTING	-	EXISTING					
201	STAIR A	EXISTING	EXISTING	-	EXISTING	EXG PNT	EXISTING	EXG PNT	EXISTING	EXG PNT	EXISTING	EXG PNT	EXISTING	EXG PNT					
202	CORRIDOR	EXISTING	EXG LVT-1	EXISTING	EXG, GYP	EXG PNT, PNT-2	EXG, GYP	EXG PNT, PNT-2	EXISTING	EXG PNT	EXISTING	WALL PAINT	EXISTING	EXG PNT					
203	CORRIDOR	EXISTING	EXG CPS-1, CPS-2	EXG R8, RB-1	EXISTING	EXG PNT	EXG, GYP	EXG PNT, PNT-2	EXISTING	EXG PNT	EXG, GYP	EXG PNT, PNT-2	EXISTING	EXG ACT, ACT NEW, EXG PNT					
203A	CLOSET	EXISTING	EXG CPS-1	EXG R8	EXISTING	EXG PNT	EXISTING	EXG PNT	EXISTING	EXG PNT	EXISTING	EXG PNT	EXISTING	EXG PNT					
203B	CLOSET	EXISTING	CPT-1	EXG R8, RB-1	GYP	PNT-2	GYP	PNT-2	GYP	PNT-2	EXISTING	WALL PAINT	GYP	PNT-2					
203C	CLOSET	EXISTING	CPT-1	EXG R8, RB-1	EXISTING	PNT-2	GYP	PNT-2	GYP	PNT-2	EXISTING	PNT-2	GYP	PNT-2					
204	MEETING	EXISTING	EXG CPS-1	EXG R8	EXISTING	EXG PNT	EXISTING	EXG PNT	EXISTING	EXG PNT	EXISTING	EXG PNT	EXISTING	EXG ACT					
205	MOVEMENT ROOM	EXISTING	EXG CPS-1	EXG R8, RB-1	EXISTING	EXG PNT	EXISTING	EXG PNT	EXISTING	EXG PNT	EXISTING	EXG PNT, PNT-2	EXISTING	EXG PNT					
206	OFFICE	EXISTING	EXG CPS-1	EXG R8	EXISTING	EXG PNT	EXISTING	EXG PNT	EXISTING	EXG PNT	EXISTING	EXG PNT	-	EXG ACT					
207	MAKER SPACE	EXISTING	MS-2	EXG R8, RB-1	EXISTING	PNT-2	EXISTING	PNT-2	EXG, GYP	PNT-2	EXISTING	PNT-2	-	ACT NEW					
208	CLASSROOM	EXISTING	CPT-1	EXG R8	EXISTING	EXG PNT	EXISTING	EXG PNT	EXISTING	EXG PNT	EXISTING	EXG PNT	-	ACT NEW					
209	ART ROOM	EXISTING	MS-2	EXG R8, RB-1	EXISTING	PNT-2	EXG, GYP	PNT-2	EXISTING	PNT-2	EXISTING	PNT-2	-	ACT NEW					
210	CLASSROOM	EXISTING	CPT-1	EXG R8, RB-1	EXISTING	PNT-2	EXISTING	EXG PNT	EXISTING	EXG PNT	EXG, GYP	EXG PNT, PNT-2	-	ACT NEW					
211	KITCHEN	EXISTING	MS-2	EXG R8, RB-1	EXG, GYP	PNT-2	EXISTING	PNT-2	EXISTING	PNT-2	EXISTING	PNT-2	-	ACT NEW					
212	OFFICE	EXISTING	EXG CPS-1	EXG R8	EXISTING	EXG PNT	EXISTING	EXG PNT	EXISTING	EXG PNT	EXISTING	EXG PNT	-	EXG ACT					
213	CONFERENCE ROOM	EXISTING	EXG CPS-1	EXG R8	EXISTING	EXG PNT	EXISTING	EXG PNT	EXISTING	EXG PNT	EXISTING	EXG PNT	-	EXG ACT					
214	STAIR B	EXISTING	EXG CPS-1	EXG R8	EXISTING	EXG PNT	EXISTING	EXG PNT	EXISTING	EXG PNT	EXISTING	EXG PNT	-	EXG ACT					
215	MUDROOM	EXISTING	MS-2	EXG R8, RB-1	EXG, GYP	PNT-2	EXISTING	EXG PNT	EXISTING	EXG PNT	EXISTING	EXG PNT	-	EXG ACT, ACT NEW					
215A	JAN. CLST	EXISTING	MS-2	-	EXISTING	-	EXISTING	-	GYP	-	EXISTING	-	-	EXG ACT, ACT NEW					
216	TLT	EXISTING	EXG MS-1	EXG R8	EXISTING	EXG PNT	EXISTING	EXG PNT	EXISTING	EXG PNT	EXISTING	EXG PNT	EXISTING	EXG PNT					
217	TLT	EXISTING	EXG MS-1	EXG R8	EXISTING	EXG PNT	EXISTING	EXG PNT	EXISTING	EXG PNT	EXISTING	EXG PNT	EXISTING	EXG PNT					
218	COMMON LOUNGE	EXISTING	EXG CPS-1, EXG LVP-1, CPT-1	EXG R8, RB-1	EXISTING	EXG PNT	EXG, GYP	EXG PNT, PNT-2	EXISTING	EXG PNT	EXISTING	EXG PNT	-	EXG ACT, ACT NEW					
218A	STOR	EXISTING	CPT-1	EXG R8, RB-1	GYP	EXG PNT, PNT-2	GYP	PNT-2	GYP	PNT-2	EXISTING	EXG PNT	GYP	PNT-2					
219	OFFICE	EXISTING	EXG CPS-1	EXG R8, RB-1	EXISTING	EXG PNT	EXISTING	EXG PNT	EXISTING	EXG PNT	EXG, GYP	EXG PNT	EXISTING	EXG PNT					
220	CLASSROOM	EXISTING	CPT-1	EXG R8, RB-1	EXISTING	EXG PNT	EXG, GYP	PNT-2	EXISTING	EXG PNT	EXISTING	EXG PNT	-	ACT NEW					
221	STAIR C	EXISTING	EXISTING	EXG R8	EXISTING	EXG PNT	EXISTING	EXG PNT	EXISTING	EXG PNT	EXISTING	EXG PNT	-	EXG ACT					
222	TLT	EXISTING	MS-2	EXG R8, RB-1	MRGB	PNT-2	EXISTING	PNT-2	MRGB	PNT-2	MRGB	PNT-2	MRGB	PNT-2					
223	TAKE A BREAK	EXISTING	EXG CPS-1	EXG R8	EXISTING	EXG PNT	EXISTING	EXG PNT	EXISTING	EXG PNT	EXISTING	EXG PNT	-	EXG ACT					
224	KITCHEN	EXISTING	MS-2	EXG R8, RB-1	EXISTING	PNT-2	EXISTING	PNT-2	EXISTING	PNT-2	EXISTING	PNT-2	-	EXG ACT, ACT NEW					
225	CLASSROOM	EXISTING	CPT-1	EXG R8, RB-1	EXISTING	EXG PNT	EXISTING	EXG PNT	EXISTING	EXG PNT, PNT-2	EXISTING	EXG PNT	-	EXG ACT					
225C	CLOSET	EXISTING	CPT-1	EXG R8	EXISTING	EXG PNT	EXISTING	EXG PNT	EXISTING	EXG PNT	EXISTING	EXG PNT	EXISTING	EXG PNT					
226	CORRIDOR	EXISTING	EXG LVP-1	EXG R8	-	-	EXISTING	EXG PNT	EXISTING	EXG PNT	EXISTING	EXG PNT	-	EXG ACT					
226A	CLOSET	EXISTING	EXG LVT-1	EXG R8	EXISTING	EXG PNT	EXISTING	EXG PNT	EXISTING	EXG PNT	EXISTING	EXG PNT	EXISTING	EXG PNT					
227	SHARED CONFERENCE ROOM	EXISTING	EXG CPS-1	EXG R8, RB-1	EXISTING	PNT-2	EXISTING	EXG PNT	EXISTING	EXG PNT	EXISTING	EXG PNT	-	EXG ACT					

MATERIAL LEGEND					
	MANUFACTURER	COLLECTION	PATTERN	COLOR	COMMENTS
BASE					
R8-1	-	-	-	-	
R8-2	-	-	MATCH EXISTING	MATCH EXISTING	
CEILING					
ACT-1	-	-	-	-	
ACT-2	-	-	MATCH EXISTING	MATCH EXISTING	
GWB-1	-	-	-	-	
GWB-2	MOISTURE RESISTANT GWB	-	-	-	
COUNTERTOPS					
CAB-1				FLUSH MAPLE VENEER DOORS & DRAWERS	ALL NEW CABINETS
HPDL-1	WILSONART		DEEPSTAR SLATE		
FLOOR FINISH					
CPS-1	EXISTING	-	SHEET	-	
CPS-2	-	-	SHEET	MATCH EXISTING	USE SALVAGED CPS-1
CPT-1	SHAWCONTRACT	GROUNDEN SPACES, IN THE FLOW	TILE	TBD	
LVP-1	EXISTING	-	PLANK	-	
LVT-1	EXISTING	-	TILE	-	
MS-1	EXISTING	-	SHEET	-	
MS-2	FORBO	-	SHEET	MATCH EXISTING	
PAINTS & STAINS					
PNT-1	EXISTING	-	-	-	
PNT-2	SHERWIN-WILLIAMS		MATCH EXISTING	MATCH EXISTING	COMPATIBLE PRIMER & 2 COATS


MATERIALS ABBV. SCHEDULE	
ABBV.	DESCRIPTION
ACT	ACOUSTICAL CEILING TILE
CONC	CONCRETE
CPS	CARPET SHEET
CPT	CARPET TILE
FRP	FIBERGLASS REINFORCED PLASTIC
GW8	GYPNUM WALL BOARD
LVP	LUXURY VINYL PLANK
LVS	LUXURY VINYL SHEET
LVT	LUXURY VINYL TILE
MR GW8	MOISTURE RESISTANT GYPNUM WALL BOARD
MS	MARMOLEUM SHEET FLOORING
N/A	NOT APPLICABLE
PLY	PLYWOOD
PNT	PAINT
PT	PORCELAIN TILE
R8	RESILIENT OR RUBBER BASE
VCT	VINYL COMPOSITION TILE
WD	WOOD
WOM	WALK OFF MAT

- SEE FINISH FLOOR PLANS FOR ADDITIONAL WALL & FLOOR FINISH INFORMATION & LOCATIONS
- SEE REFLECTED CEILING PLANS FOR ADDITIONAL CEILING INFORMATION.
- PROVIDE MOISTURE RESISTANT GYP BD IN ALL TOILET & BATHROOMS.

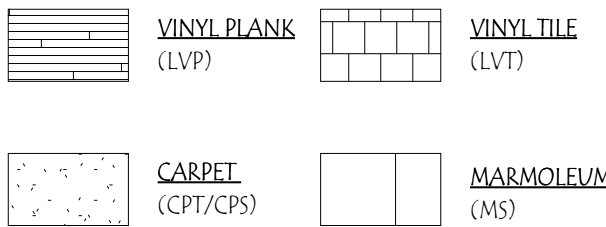


FINISH SCHEDULE NOTES

FLOOR FINISH KEY

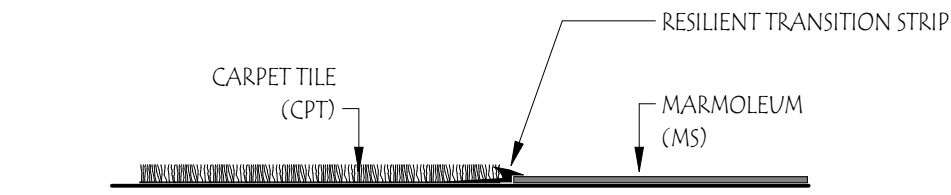


2 TYPICAL CPT TO MARMOLEUM

A600 3" = 1'-0"

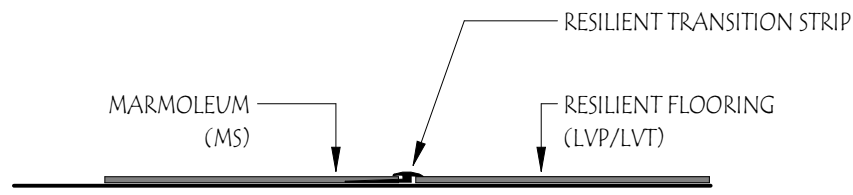

8 TYPICAL MARMOLEUM TO VINYL

A600 3" = 1'-0"

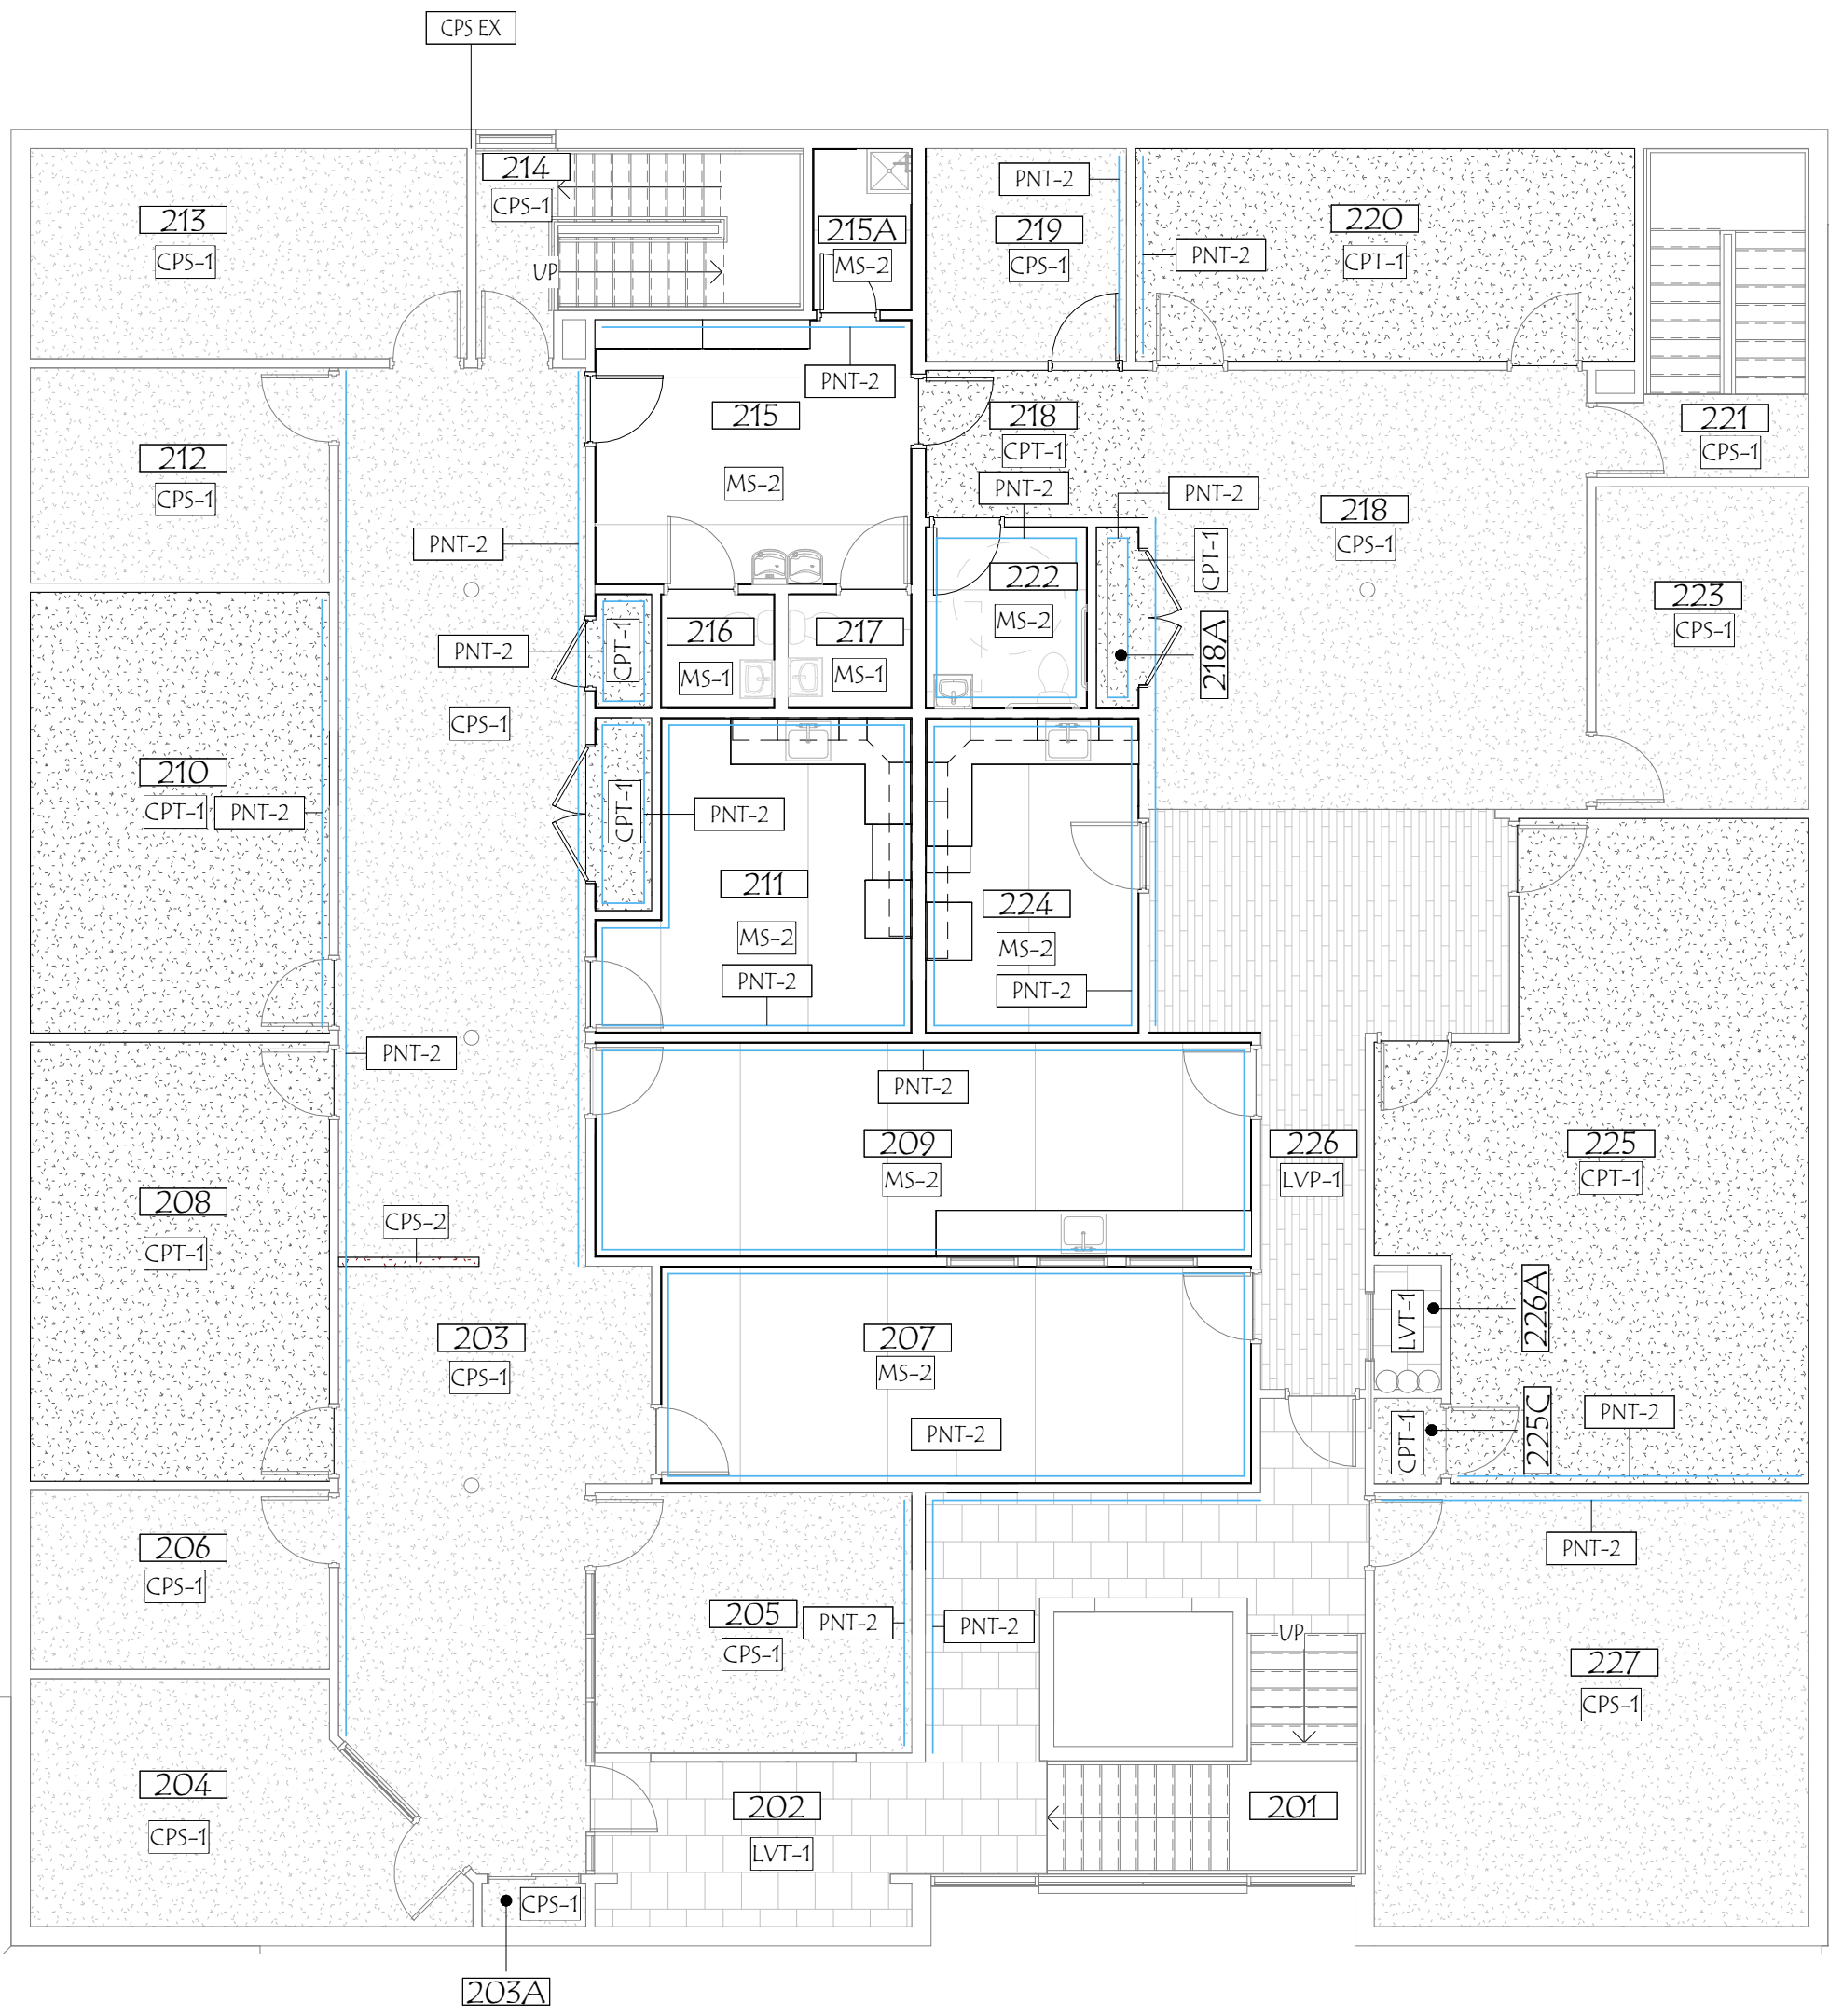

1 2ND FLOOR - FINISH PLAN

A600 1/8" = 1'-0"



38 Eastwood Drive
Suite 301
South Burlington, VT 05403
802.655.5020

wla-vt.com

OWNER
SOUTH BURLINGTON SCHOOL DISTRICT
ATTN: JEAN-MAURICE CLARK
577 DORSET STREET
SOUTH BURLINGTON, VT 05403

ARCHITECT
WIEMANN LAMPHERE ARCHITECTS
ATTN: KELLEY DESROCHES
38 EASTWOOD DRIVE, SUITE 301
SOUTH BURLINGTON, VT 05403
802.655.5020

PROJECT STATUS
NOT FOR CONSTRUCTION

#	DATE	REVISION DESCRIPTION
---	------	----------------------

SOUTH BURLINGTON SCHOOL DISTRICT OFFICES

SOUTH BURLINGTON, VERMONT



SECOND FLOOR FINISH PLAN AND SCHEDULE

PROJECT NO:	2026015
PROGRESS PRINT:	5/19/2026 11:07:53 AM
CHECKED BY:	KD
DRAWN BY:	CG
SCALE:	As indicated

A600



38 Eastwood Drive
Suite 301
South Burlington, VT 05403
802.655.5020


wla-vt.com

OWNER
SOUTH BURLINGTON SCHOOL DISTRICT
ATTN: JEAN-MAIE CLARK
577 DORSET STREET
SOUTH BURLINGTON, VT 05403

ARCHITECT
WIEMANN LAMPHERE ARCHITECTS
ATTN: KELLEY DESROCHES
38 EASTWOOD DRIVE, SUITE 301
SOUTH BURLINGTON, VT 05403
802.655.5020



1 LEVEL 2
A700 3/16" = 1'-0"

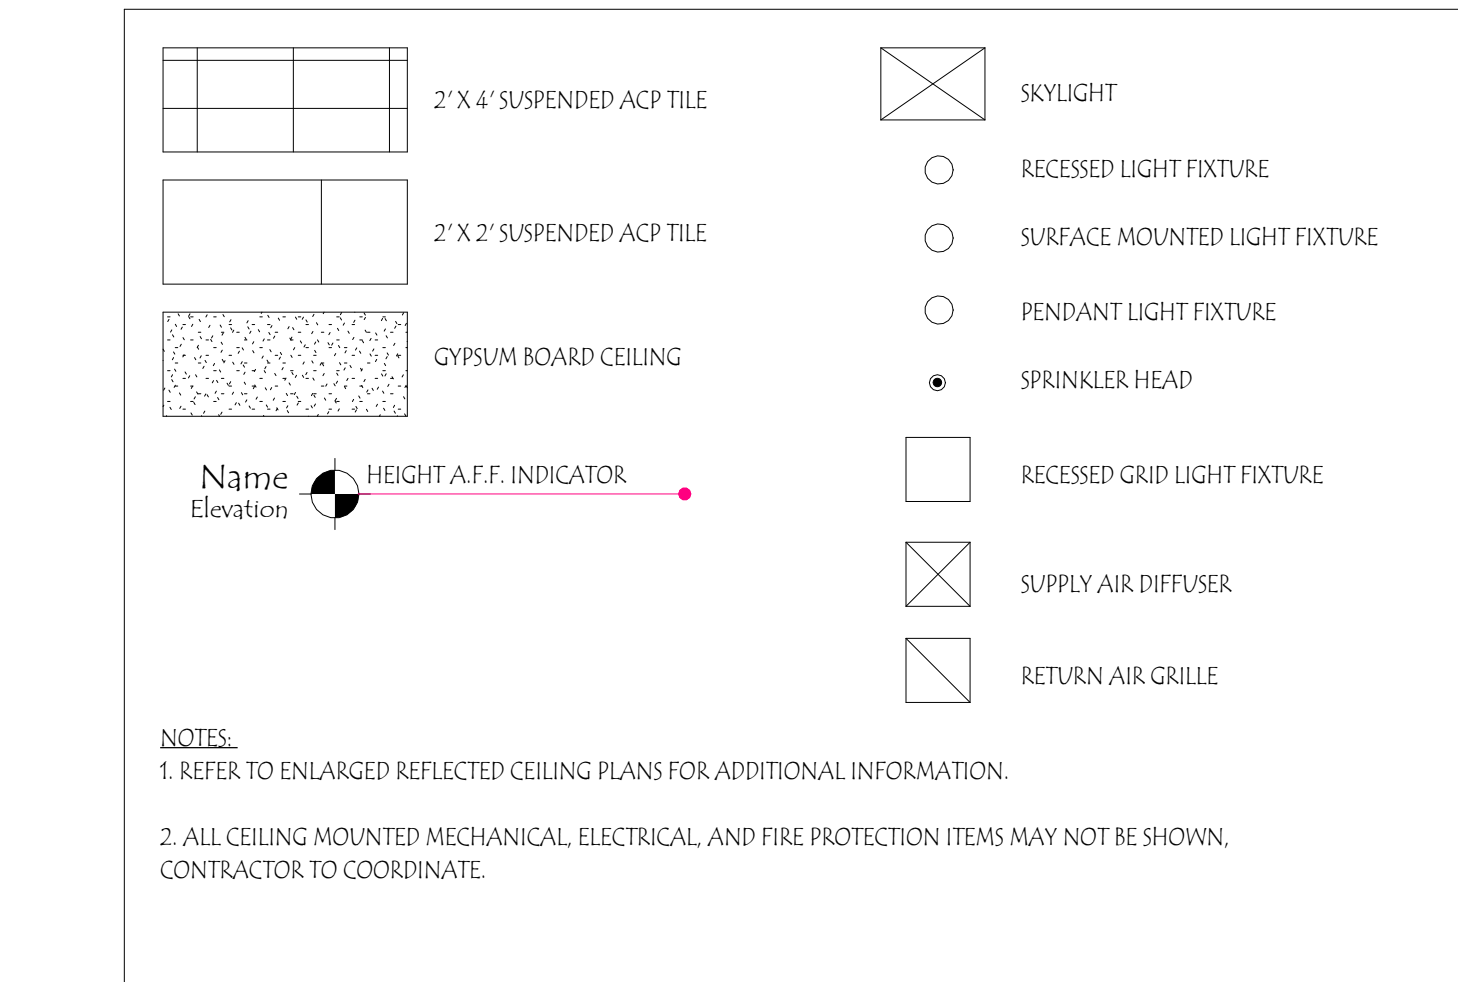

RCP KEY LEGEND
1/4" = 1'-0"

PROJECT STATUS
NOT FOR CONSTRUCTION

DATE REVISION DESCRIPTION

SOUTH BURLINGTON SCHOOL DISTRICT OFFICES

SOUTH BURLINGTON, VERMONT

SECOND FLOOR RCP

PROJECT NO: 2026015
PROGRESS PRINT: 5/19/2026 11:07:57 AM
CHECKED BY: KD
DRAWN BY: CG
SCALE: As indicated

A700